


Ground floor R₁

PROJECT:	Eulex MITROVICA Camp		
DRAWING:	Ground floor R1 - Heating system		
CHECKED BY:			
DESIGNED BY:			
SCALE:	1:100		
UNIT	cm		
DRAWING No:	1	B1	
DATE:	MAY 2010		



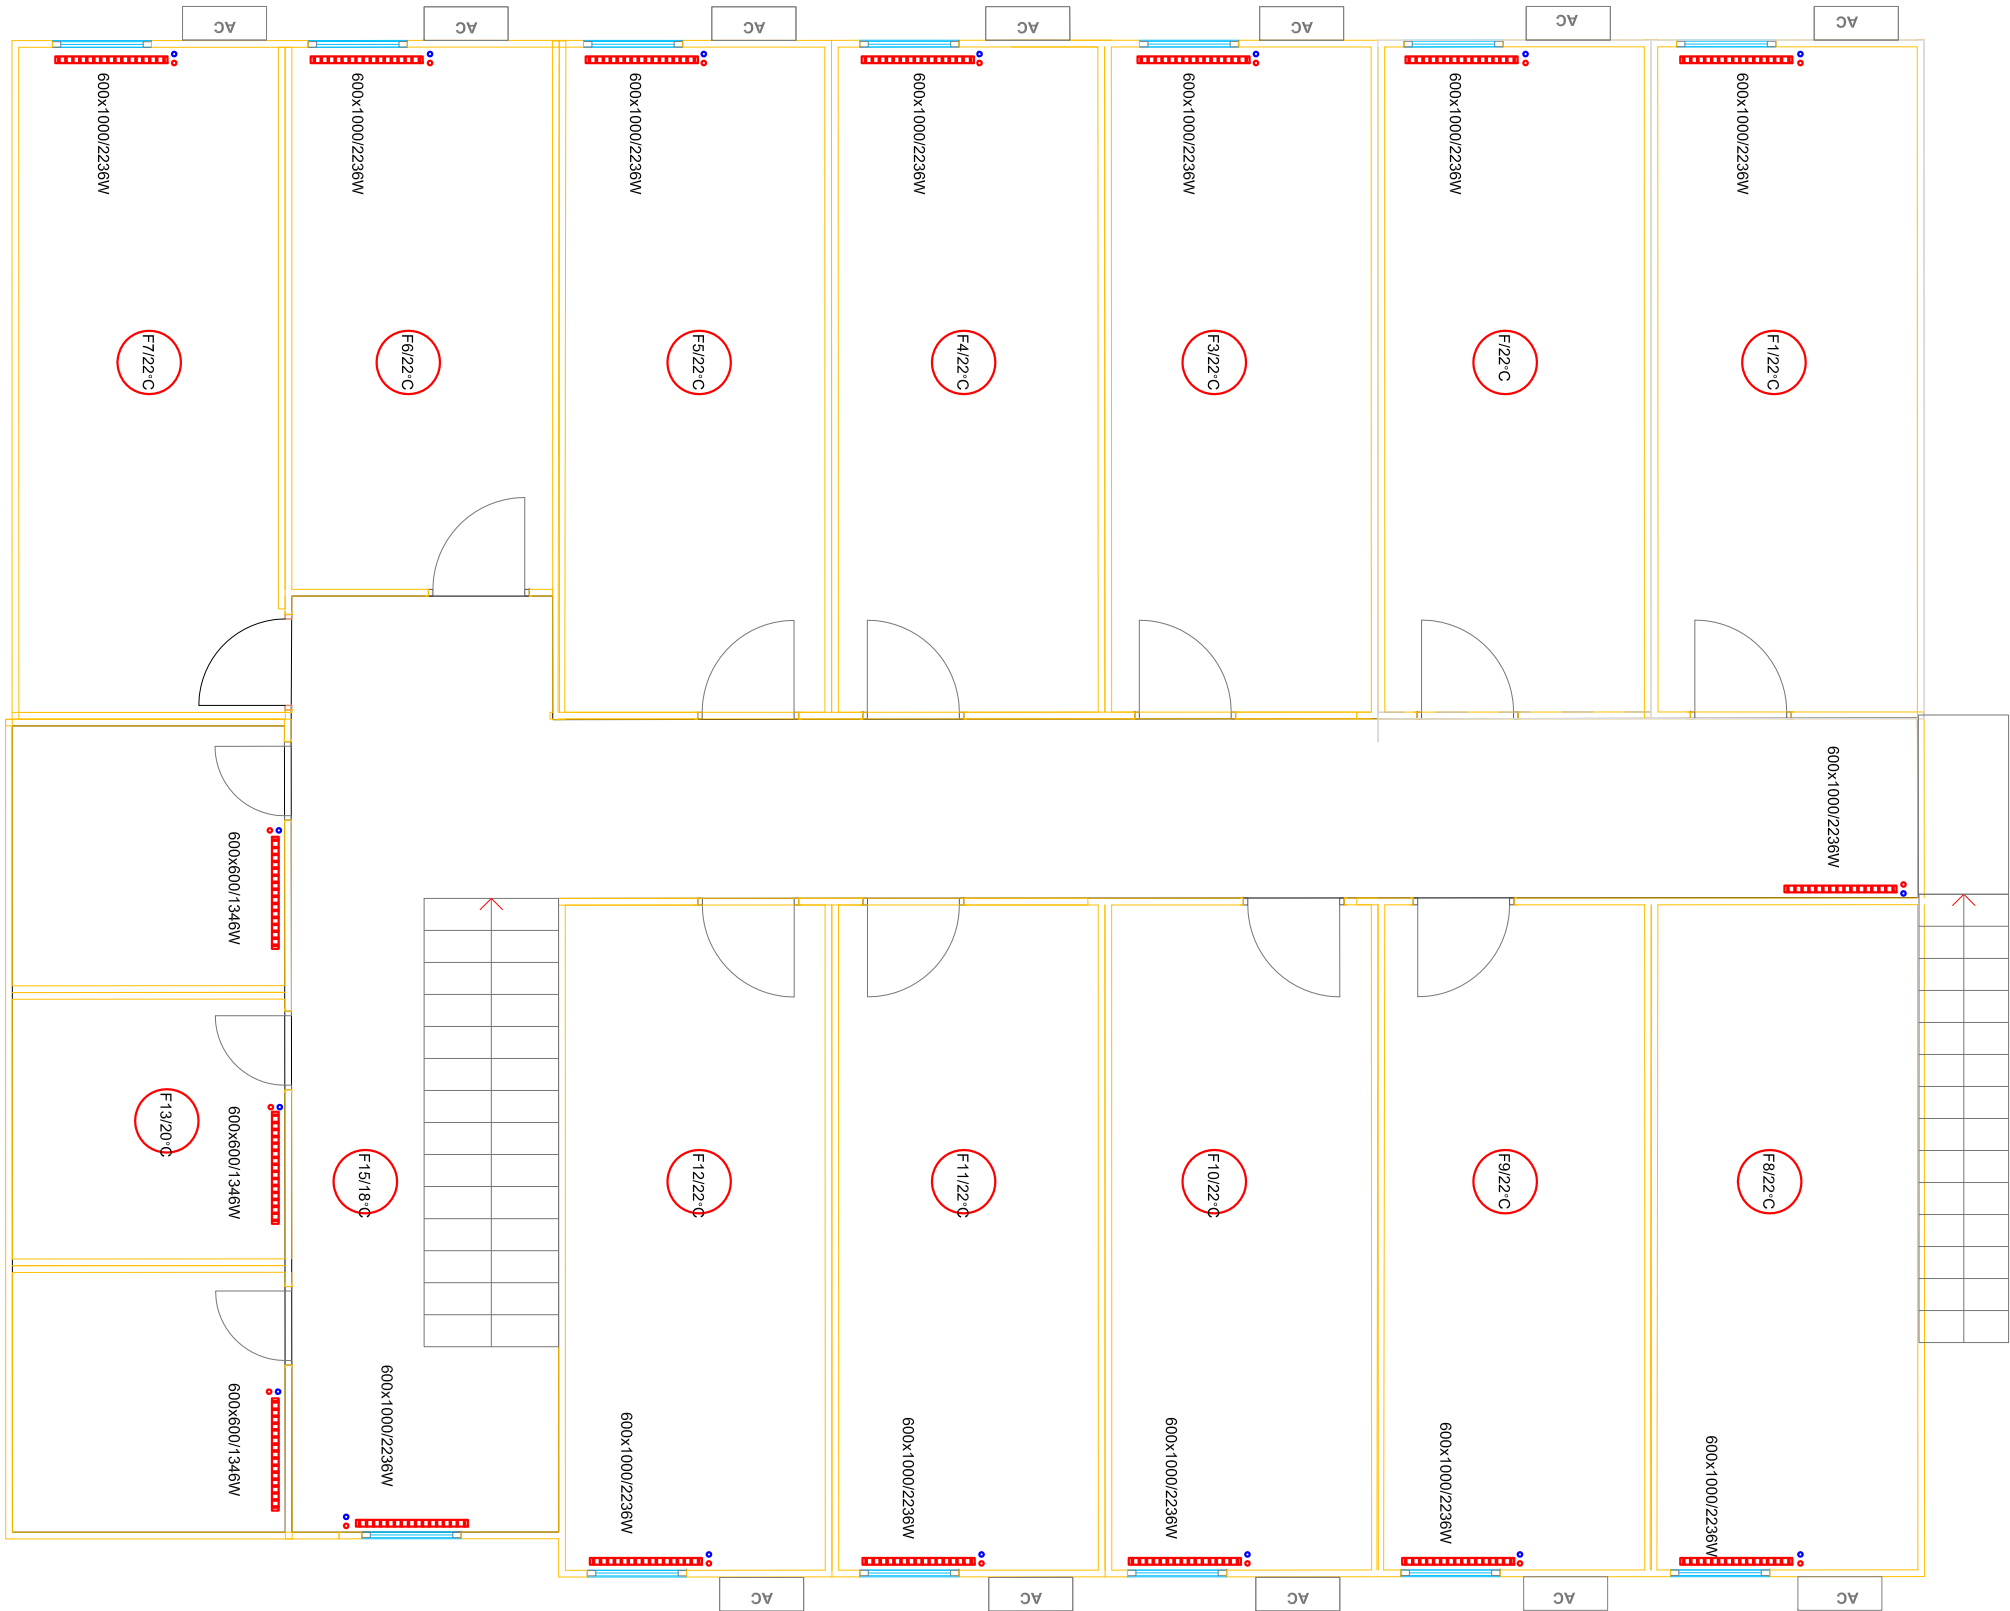


First Floor R₁ block

PROJECT:	Eulex MITROVICA Camp		
DRAWING:	First floor R1 - Heating system		
CHECKED BY:			
DESIGNED BY:			
SCALE:	1:100		
UNIT	cm		
DRAWING No:	2	B1	
DATE:	MAY 2010		




BUILDING MANAGEMENT
SECTION

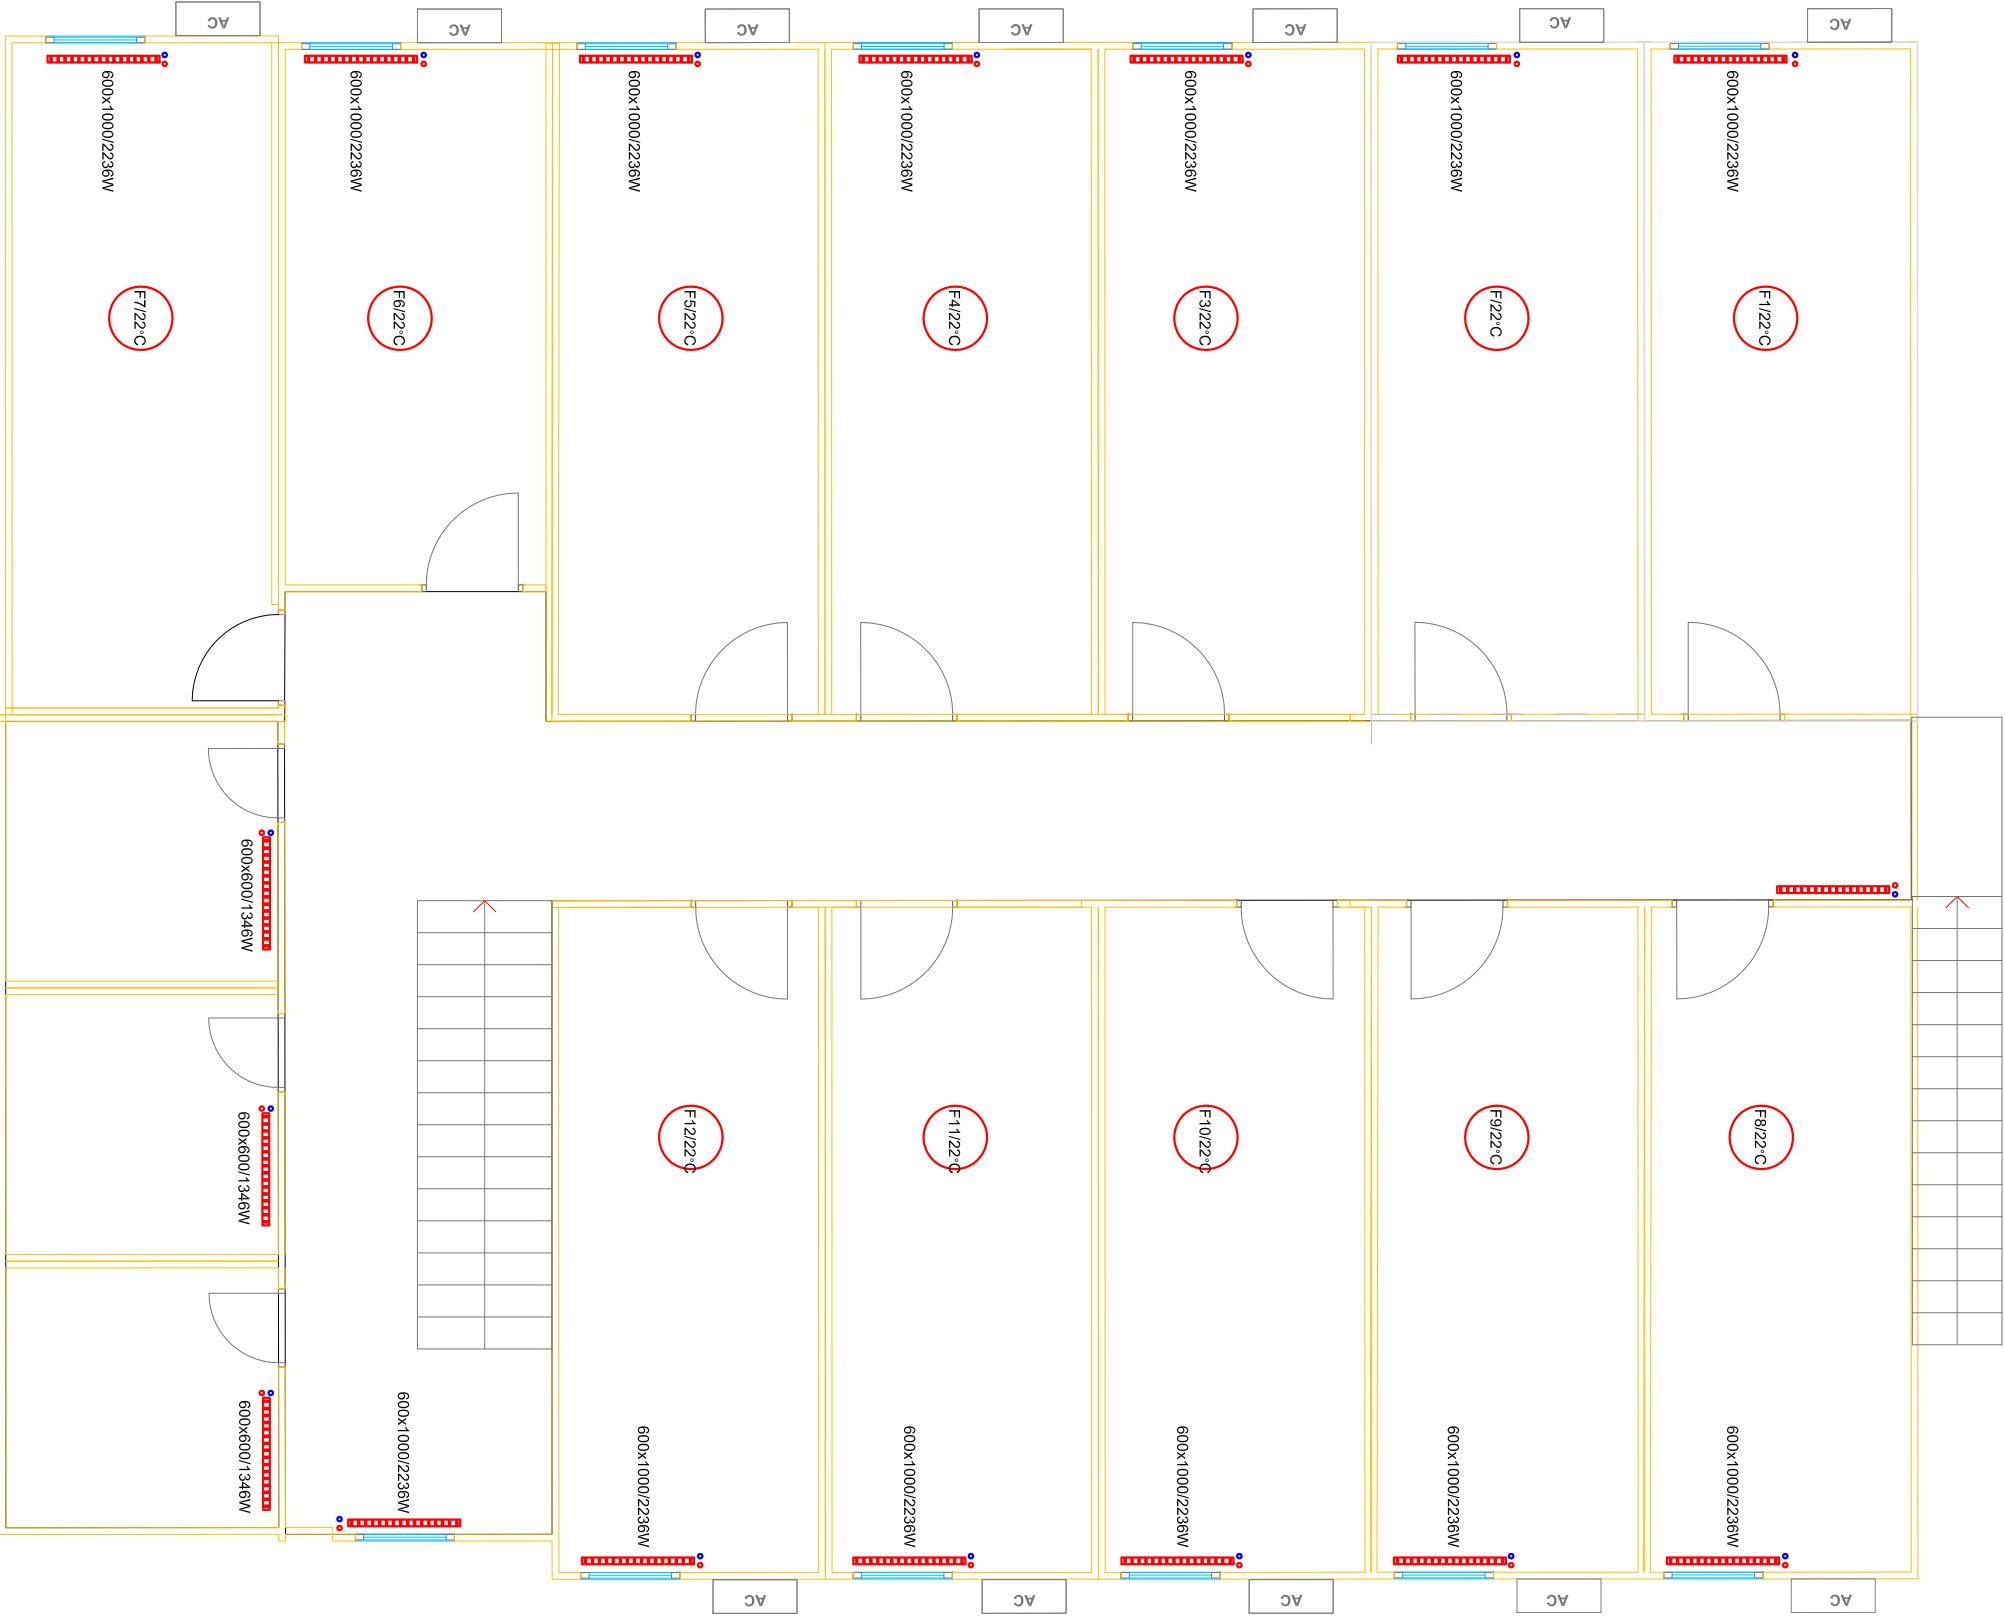

First Floor R₂ block

PROJECT:	Eulex MITROVICA Camp		
DRAWING:	First floor R2 - Heating system		
CHECKED BY:			
DESIGNED BY:			
SCALE:	1:100		
UNIT	cm		
DRAWING No:	4	B1	
DATE:	MAY 2010		



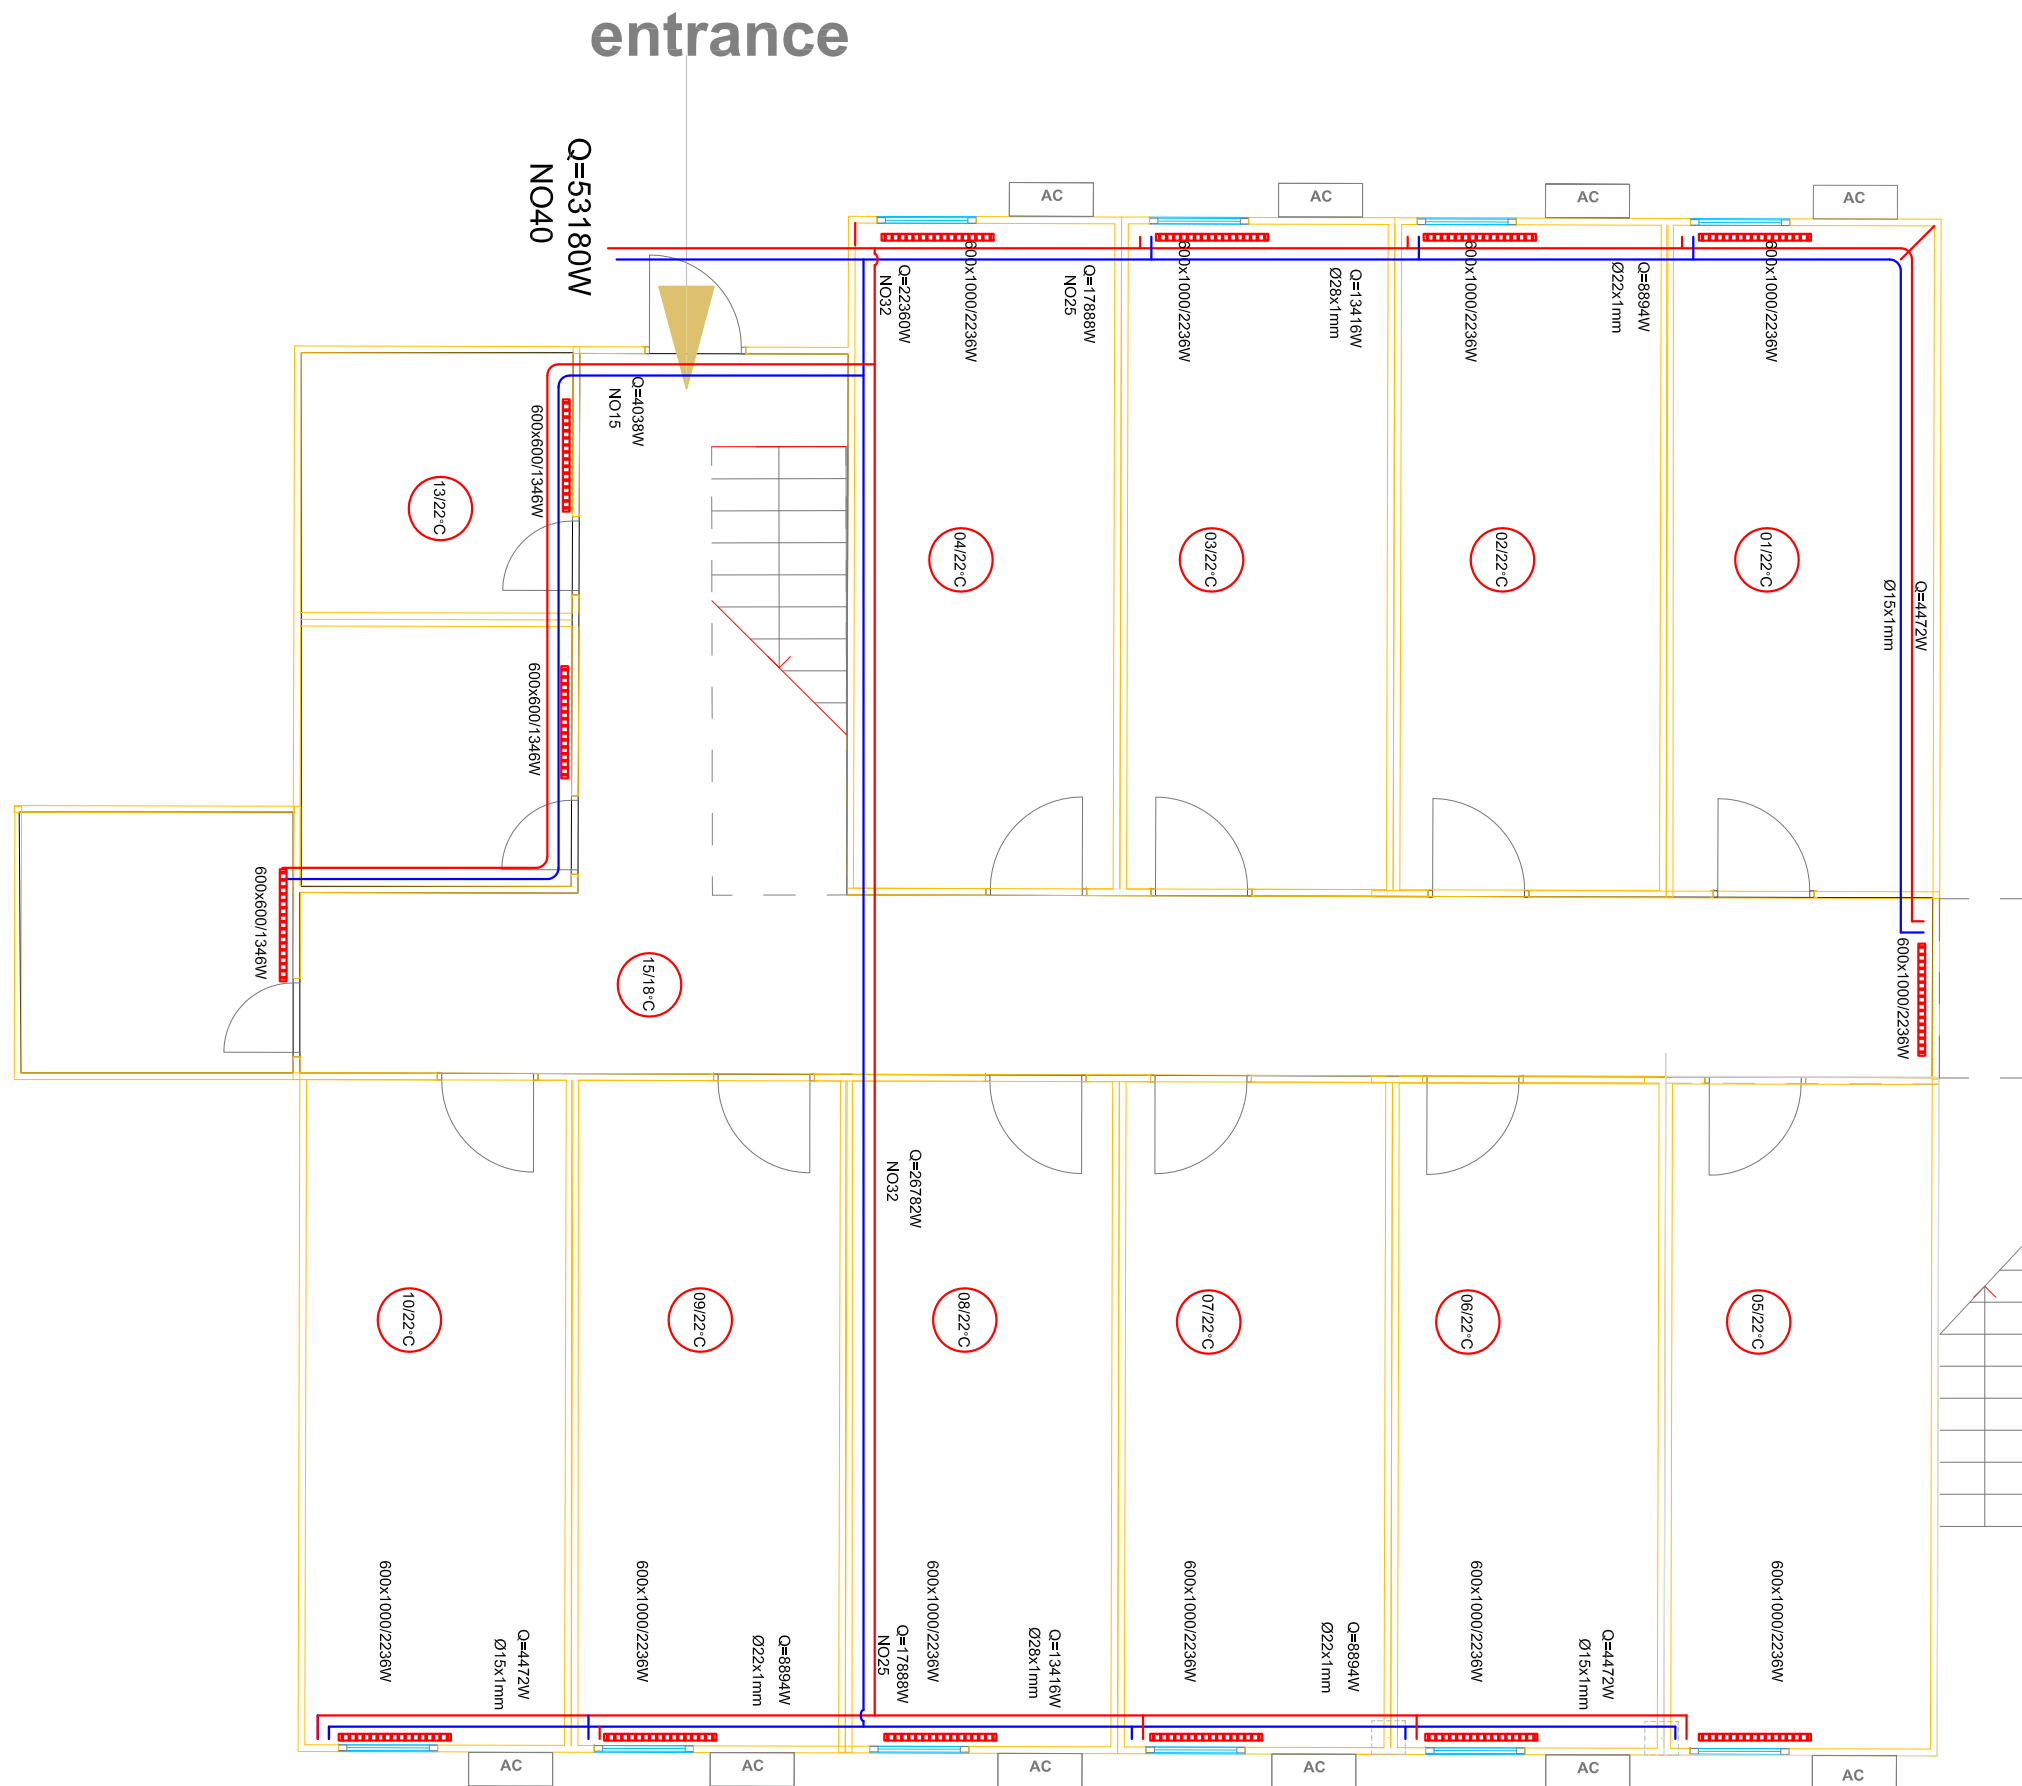


Ground floor Plan R3 block

PROJECT:	Eulex MITROVICA Camp		
DRAWING:	Ground floor R3 - Heating system		
CHECKED BY:			
DESIGNED BY:			
SCALE:	1:100		
UNIT	cm		
DRAWING No:	5	B1	
DATE:	MAY 2010		



Qr3=28931W

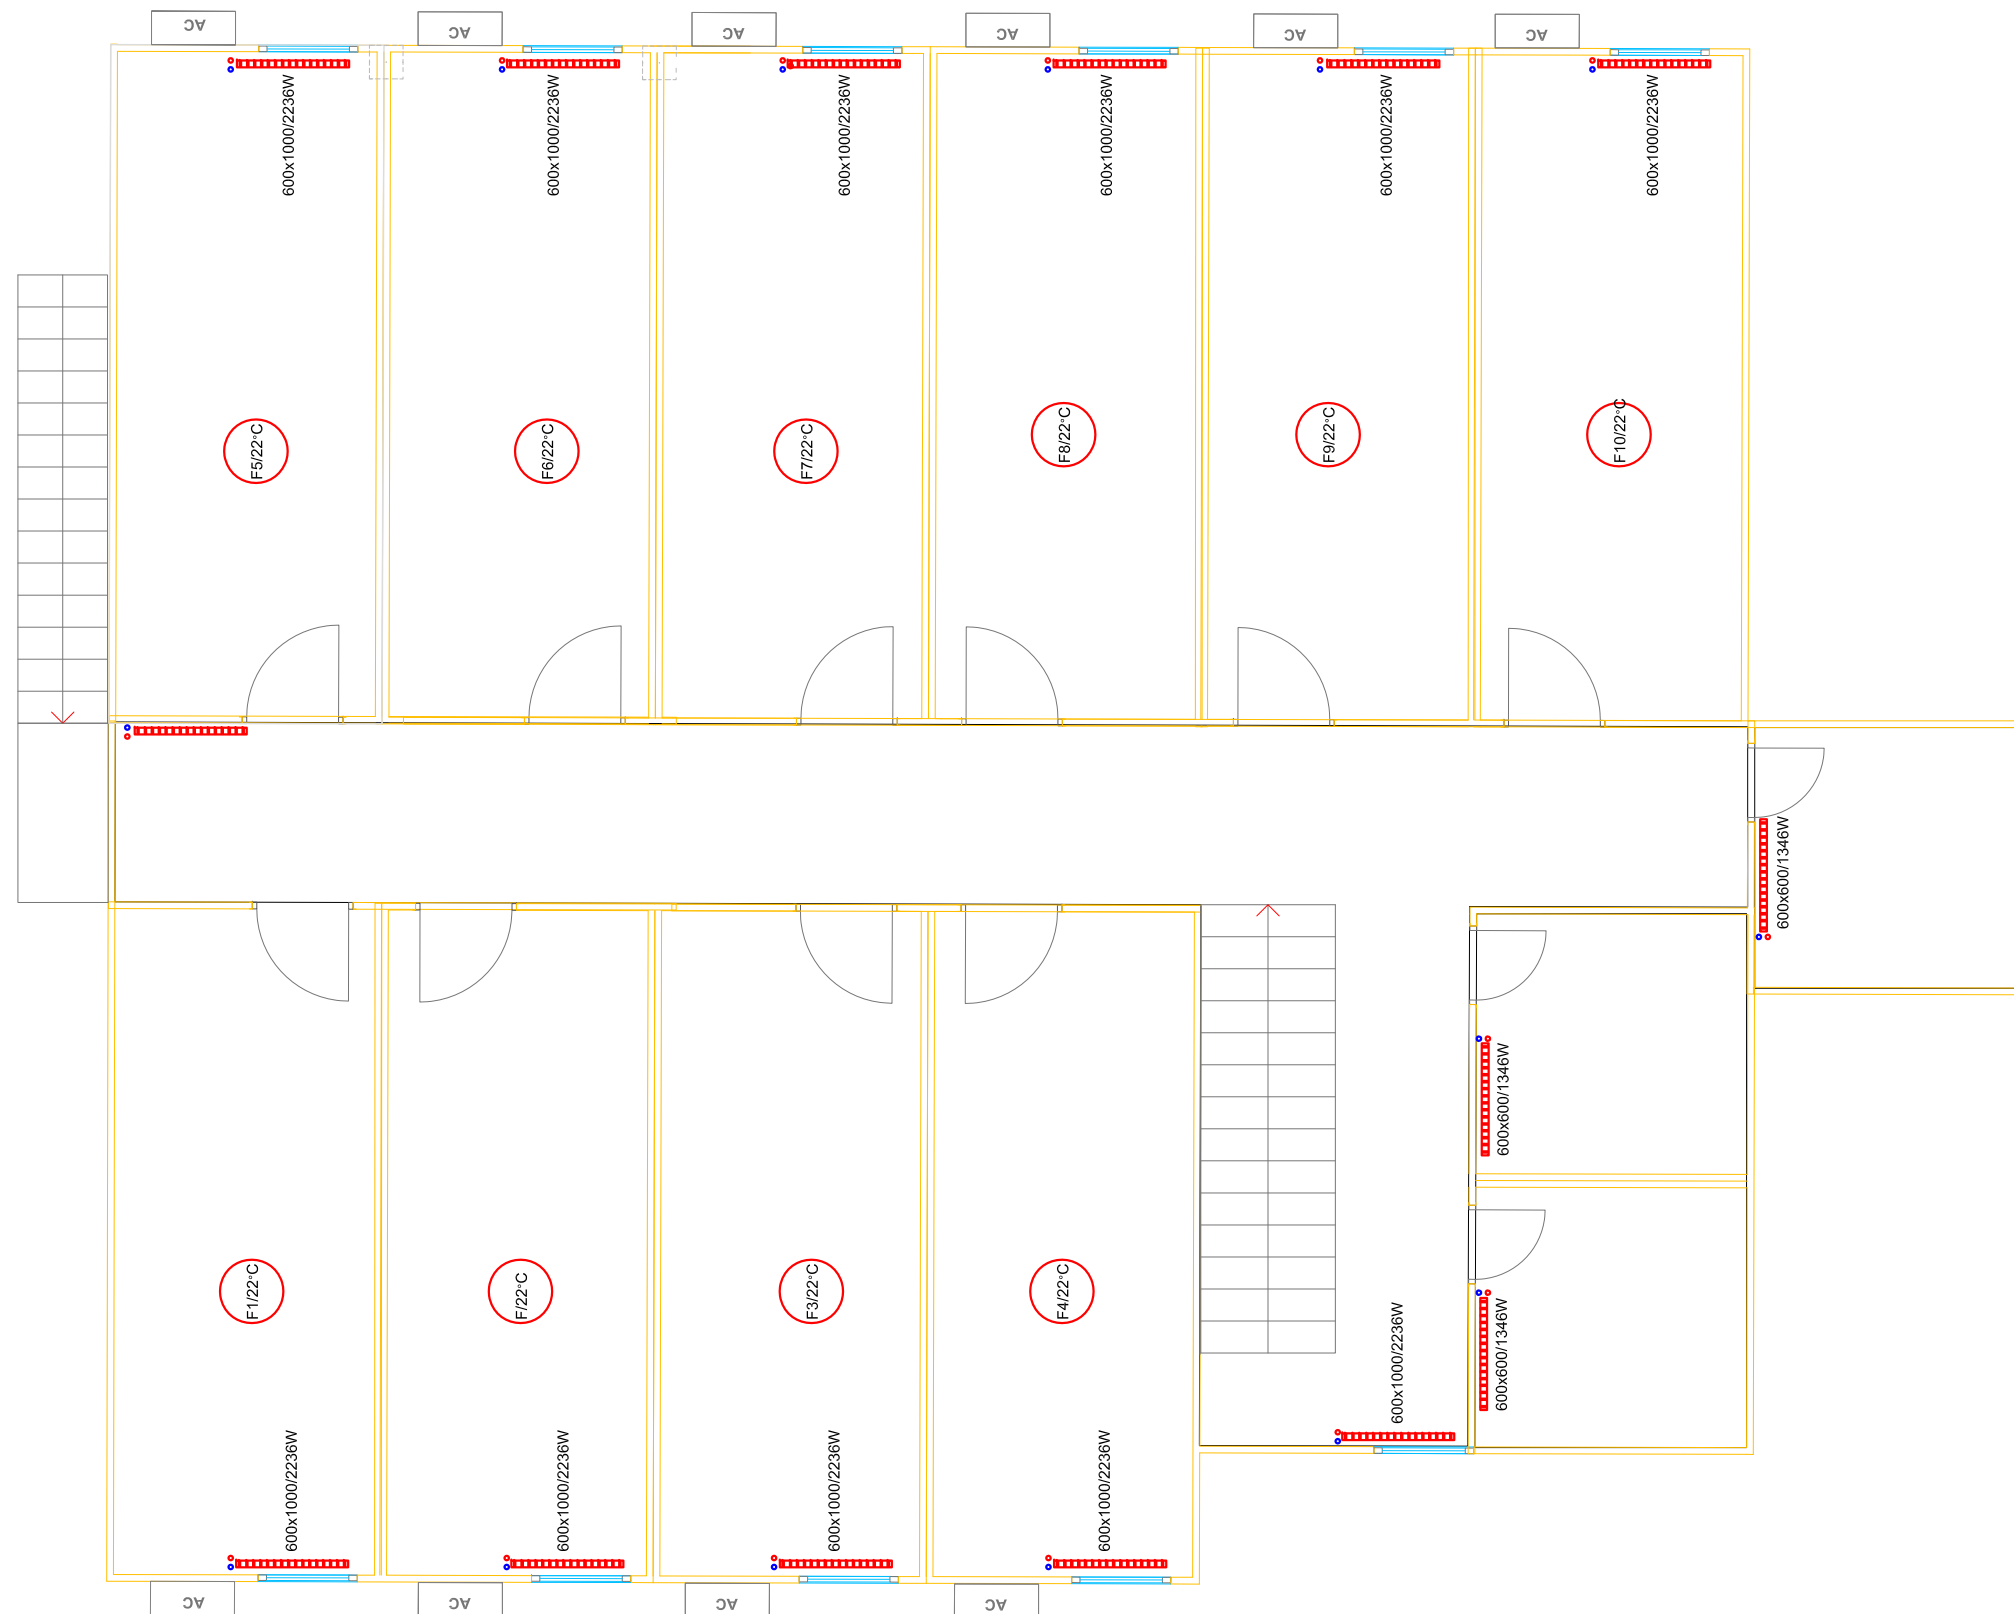


First Floor R3 block

PROJECT:	Eulex MITROVICA Camp		
DRAWING:	First floor R3 - Heating system		
CHECKED BY:			
DESIGNED BY:			
SCALE:	1:100		
UNIT	cm		
DRAWING No:	6	B1	
DATE:	MAY 2010		




BUILDING MANAGEMENT SECTION

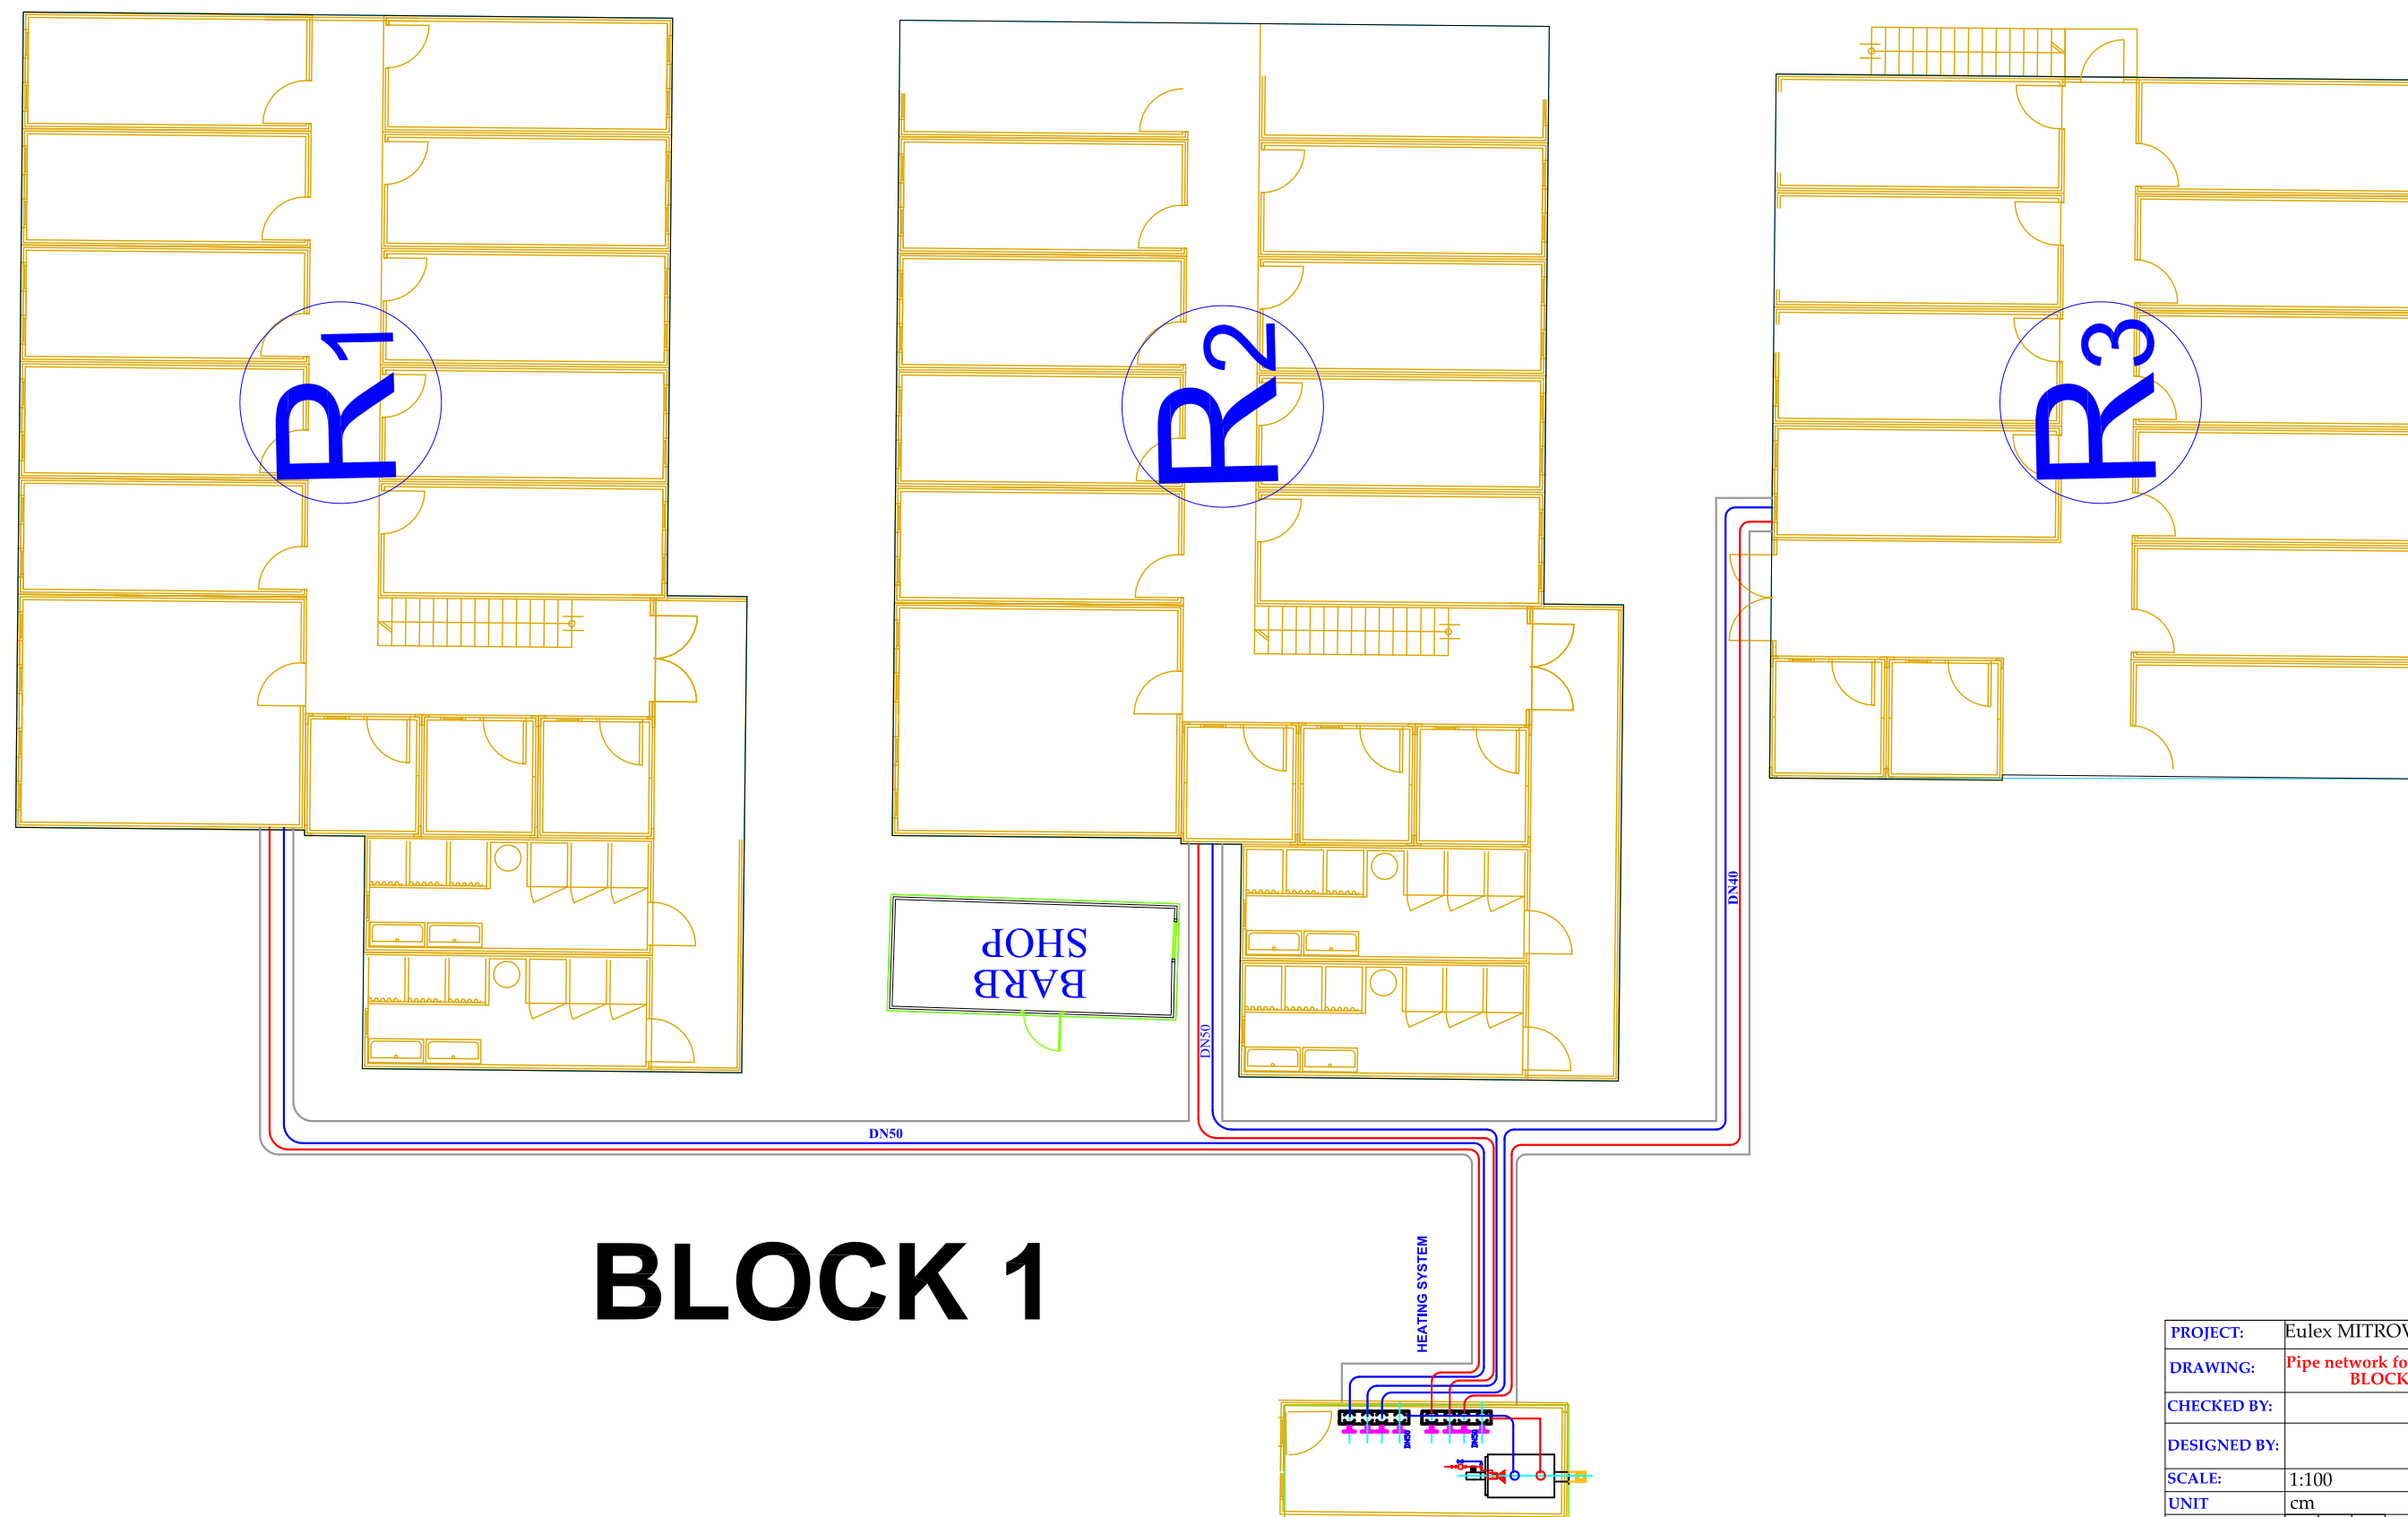

BLOCK 1

PROJECT:	Eulex MITROVICA Camp		
DRAWING:	Pipe network for heating - BLOCK 1		
CHECKED BY:			
DESIGNED BY:			
SCALE:	1:100		
UNIT	cm		
DRAWING No:	7	B1	
DATE:	MAY 2010		



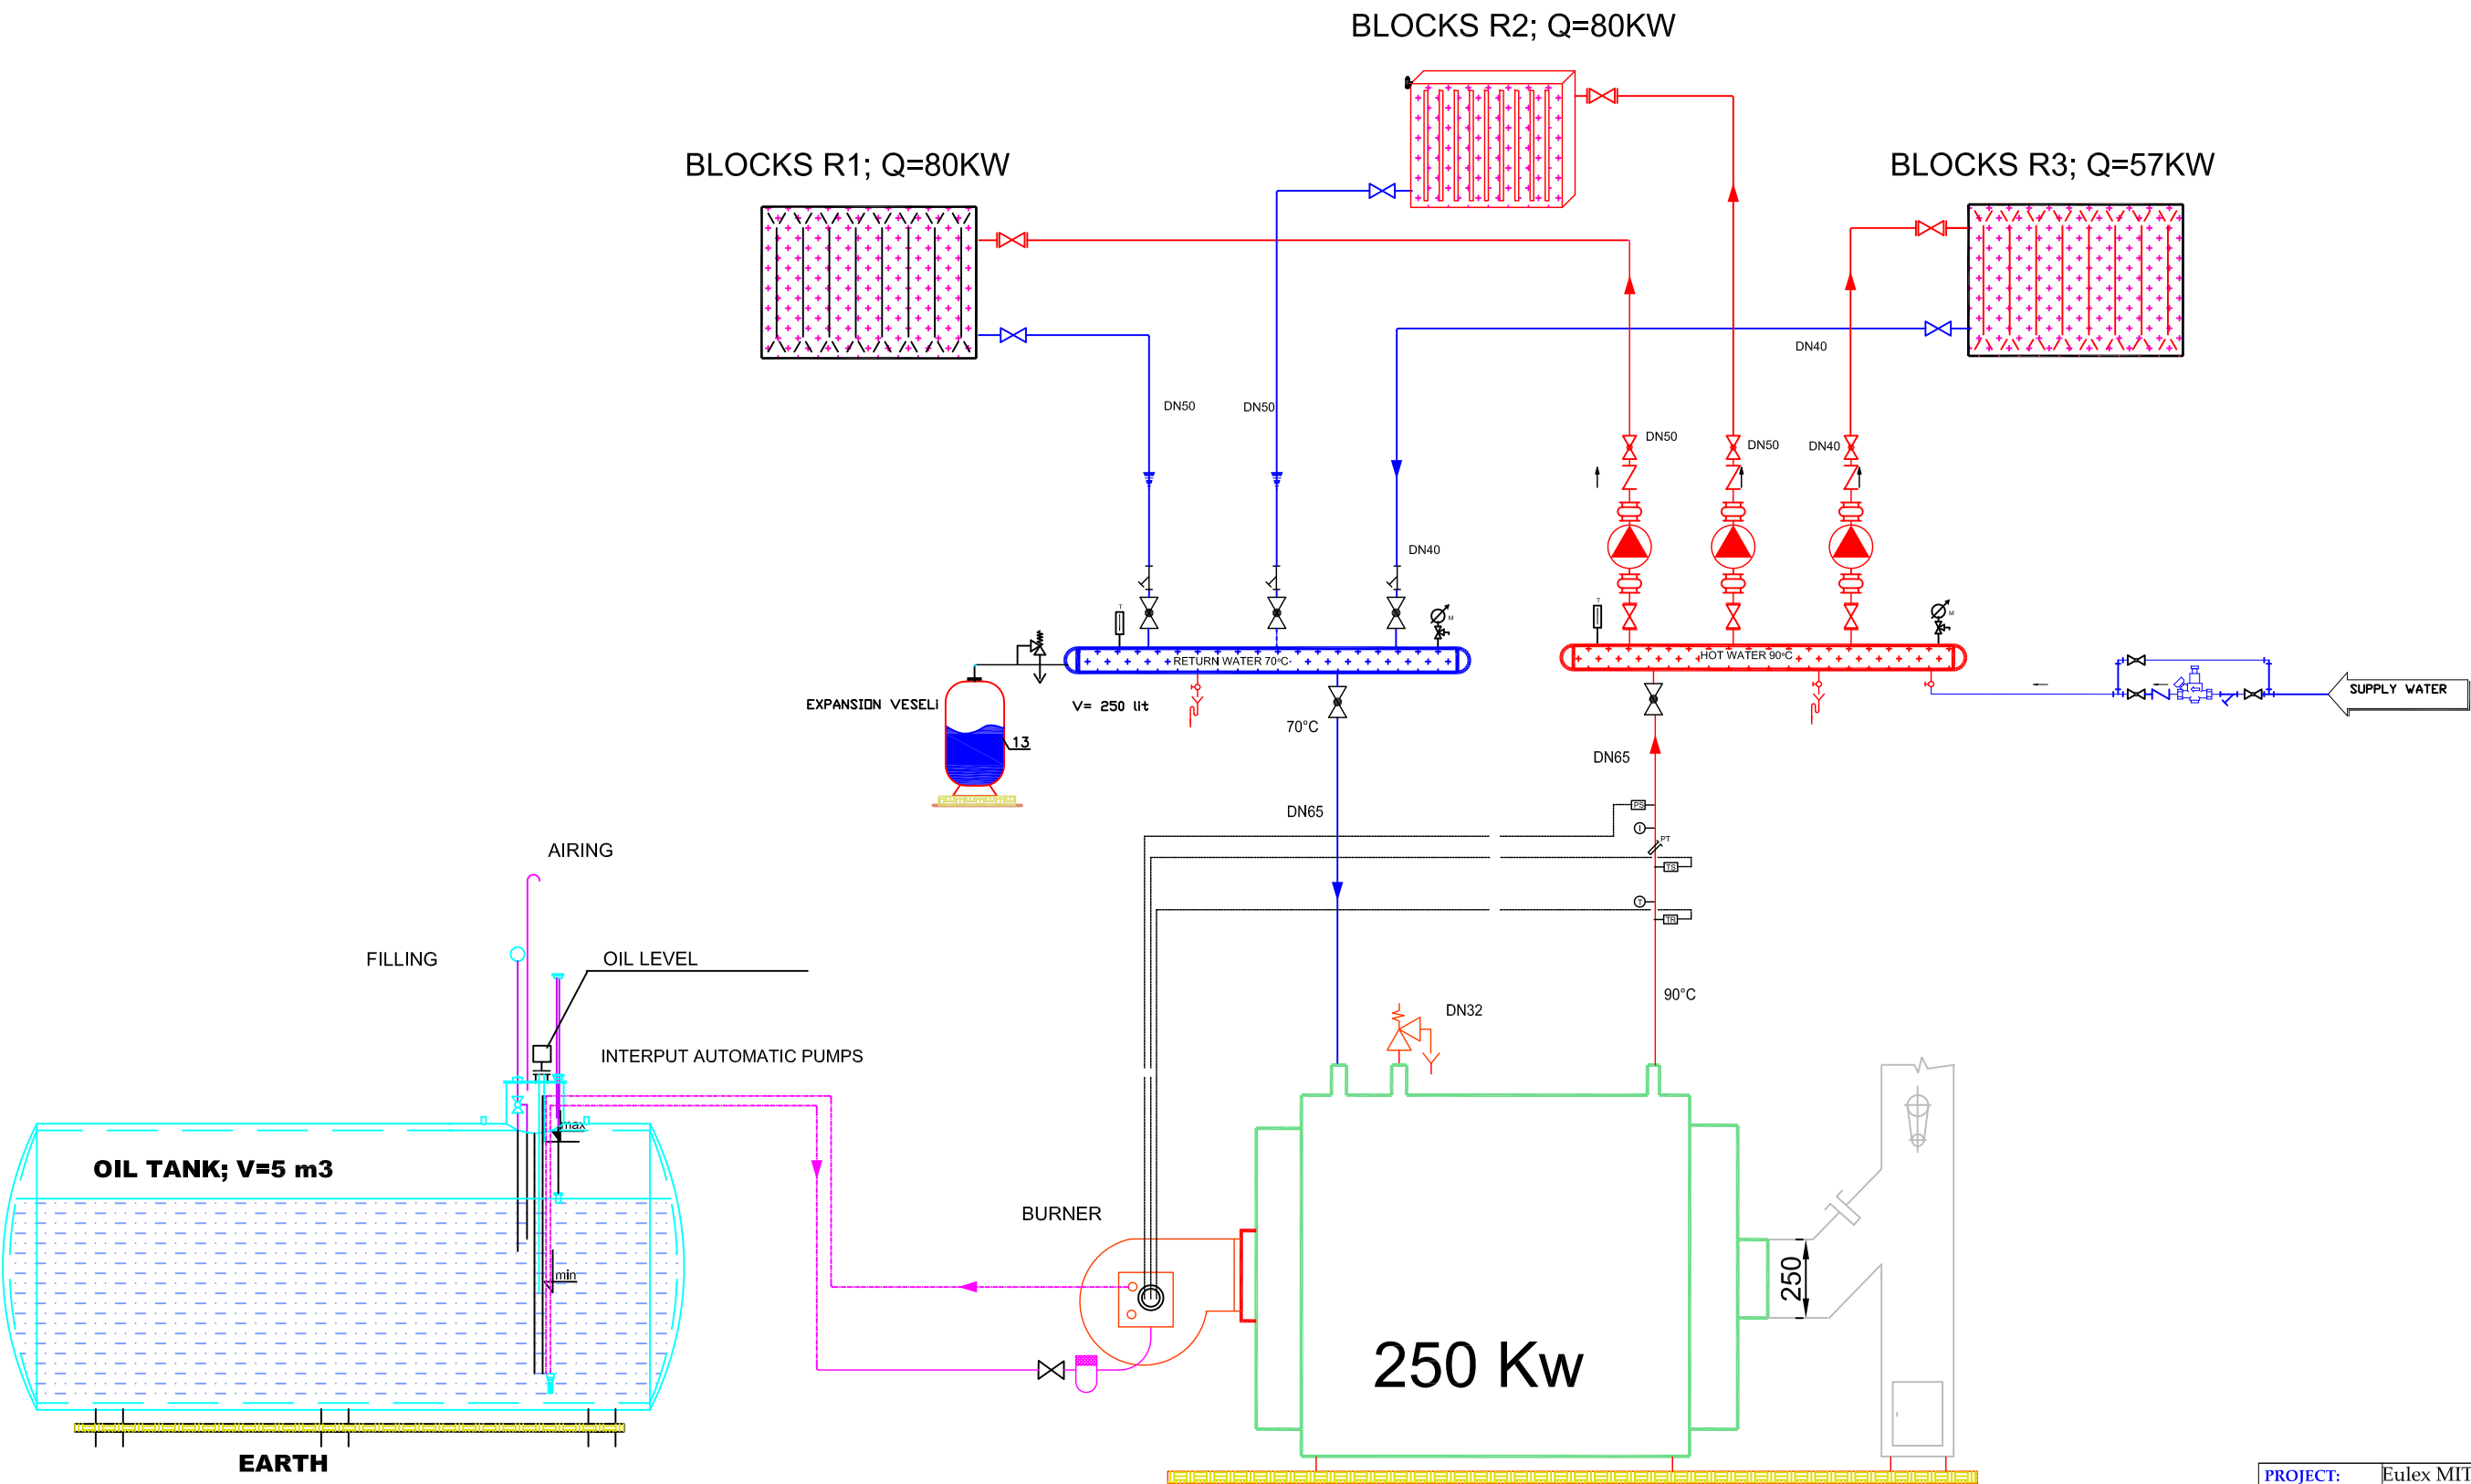

PROJECT:	Eulex MITROVICA Camp		
DRAWING:	Functional schema - BLOCK 1		
CHECKED BY:			
DESIGNED BY:			
SCALE:	1:100		
UNIT:	cm		
DRAWING No:	8	B1	
DATE:	MAY 2010		

