


Ground floor Plan O1 block


PROJECT:	Eulex MITROVICA Camp		
DRAWING:	Ground floor O1 - Heating system		
CHECKED BY:			
DESIGNED BY:			
SCALE:	1:100		
UNIT	cm		
DRAWING No:	9	B2	
DATE:	MAY 2010		

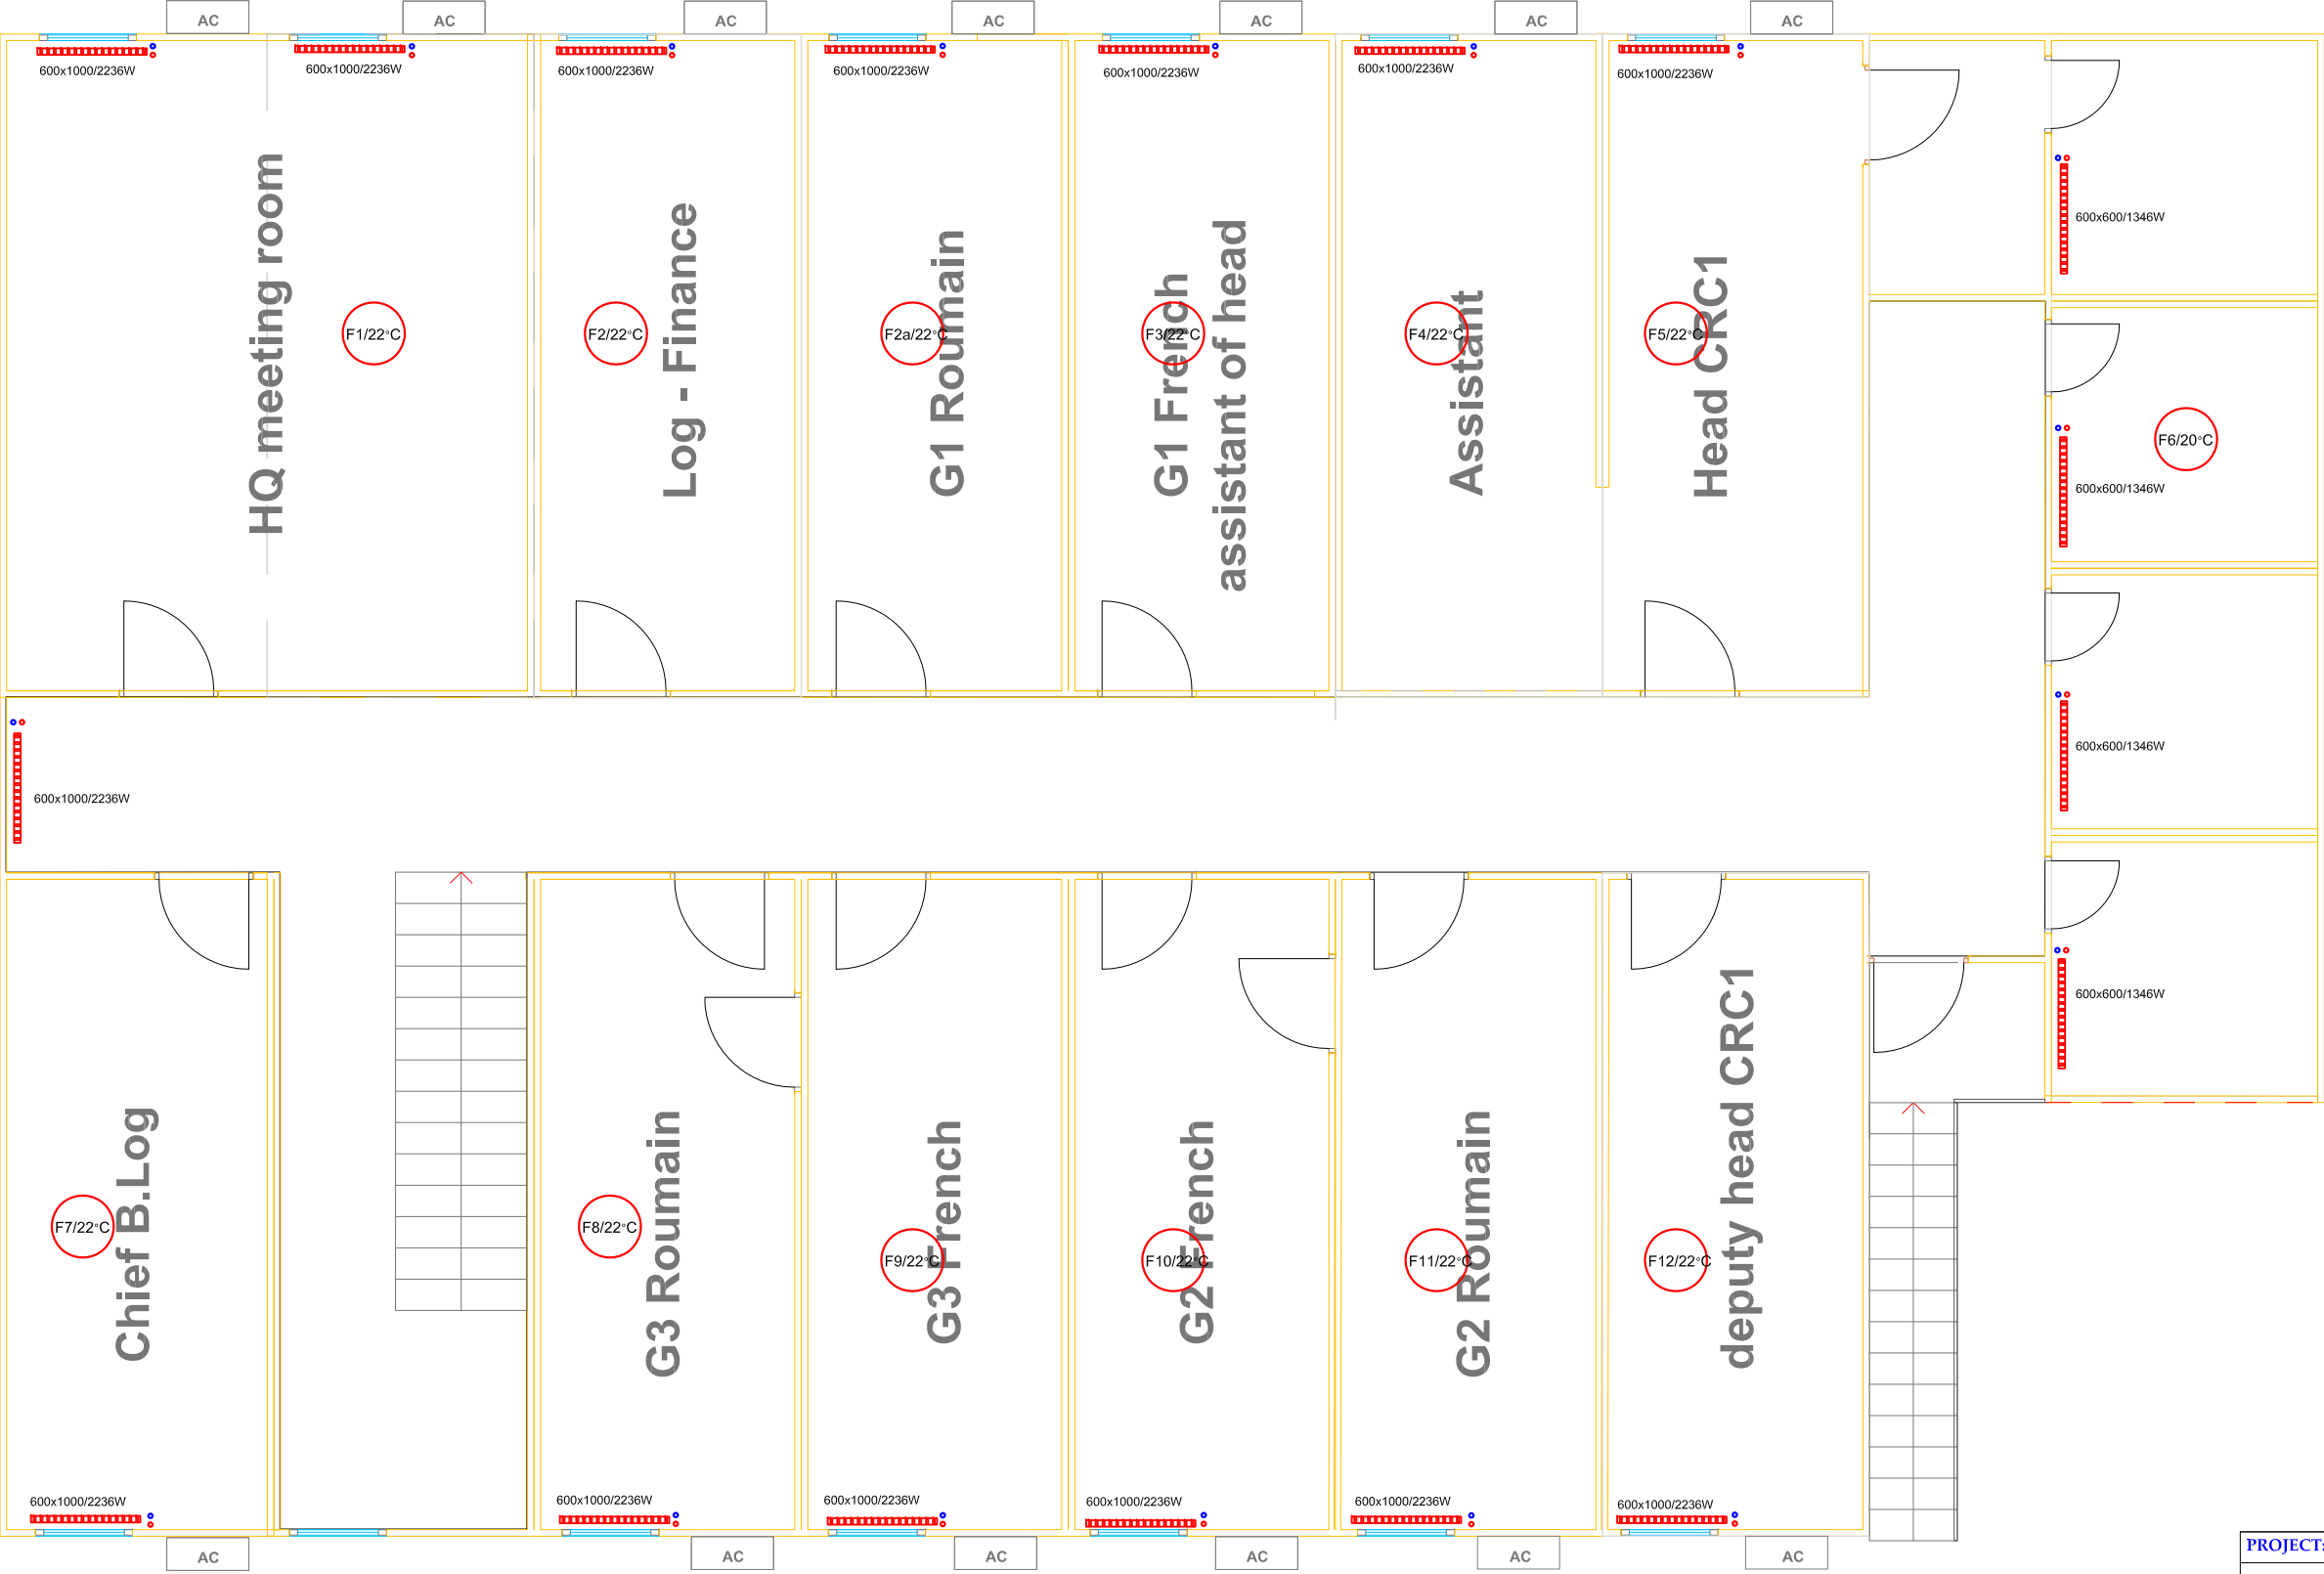




First Floor O1 block

PROJECT:	Eulex MITROVICA Camp		
DRAWING:	First floor O1 - Heating system		
CHECKED BY:			
DESIGNED BY:			
SCALE:	1:100		
UNIT	cm		
DRAWING No:	10	B2	
DATE:	MAY 2010		


BUILDING MANAGEMENT
SECTION

Q=49192W
Ø35x1mm

DN32

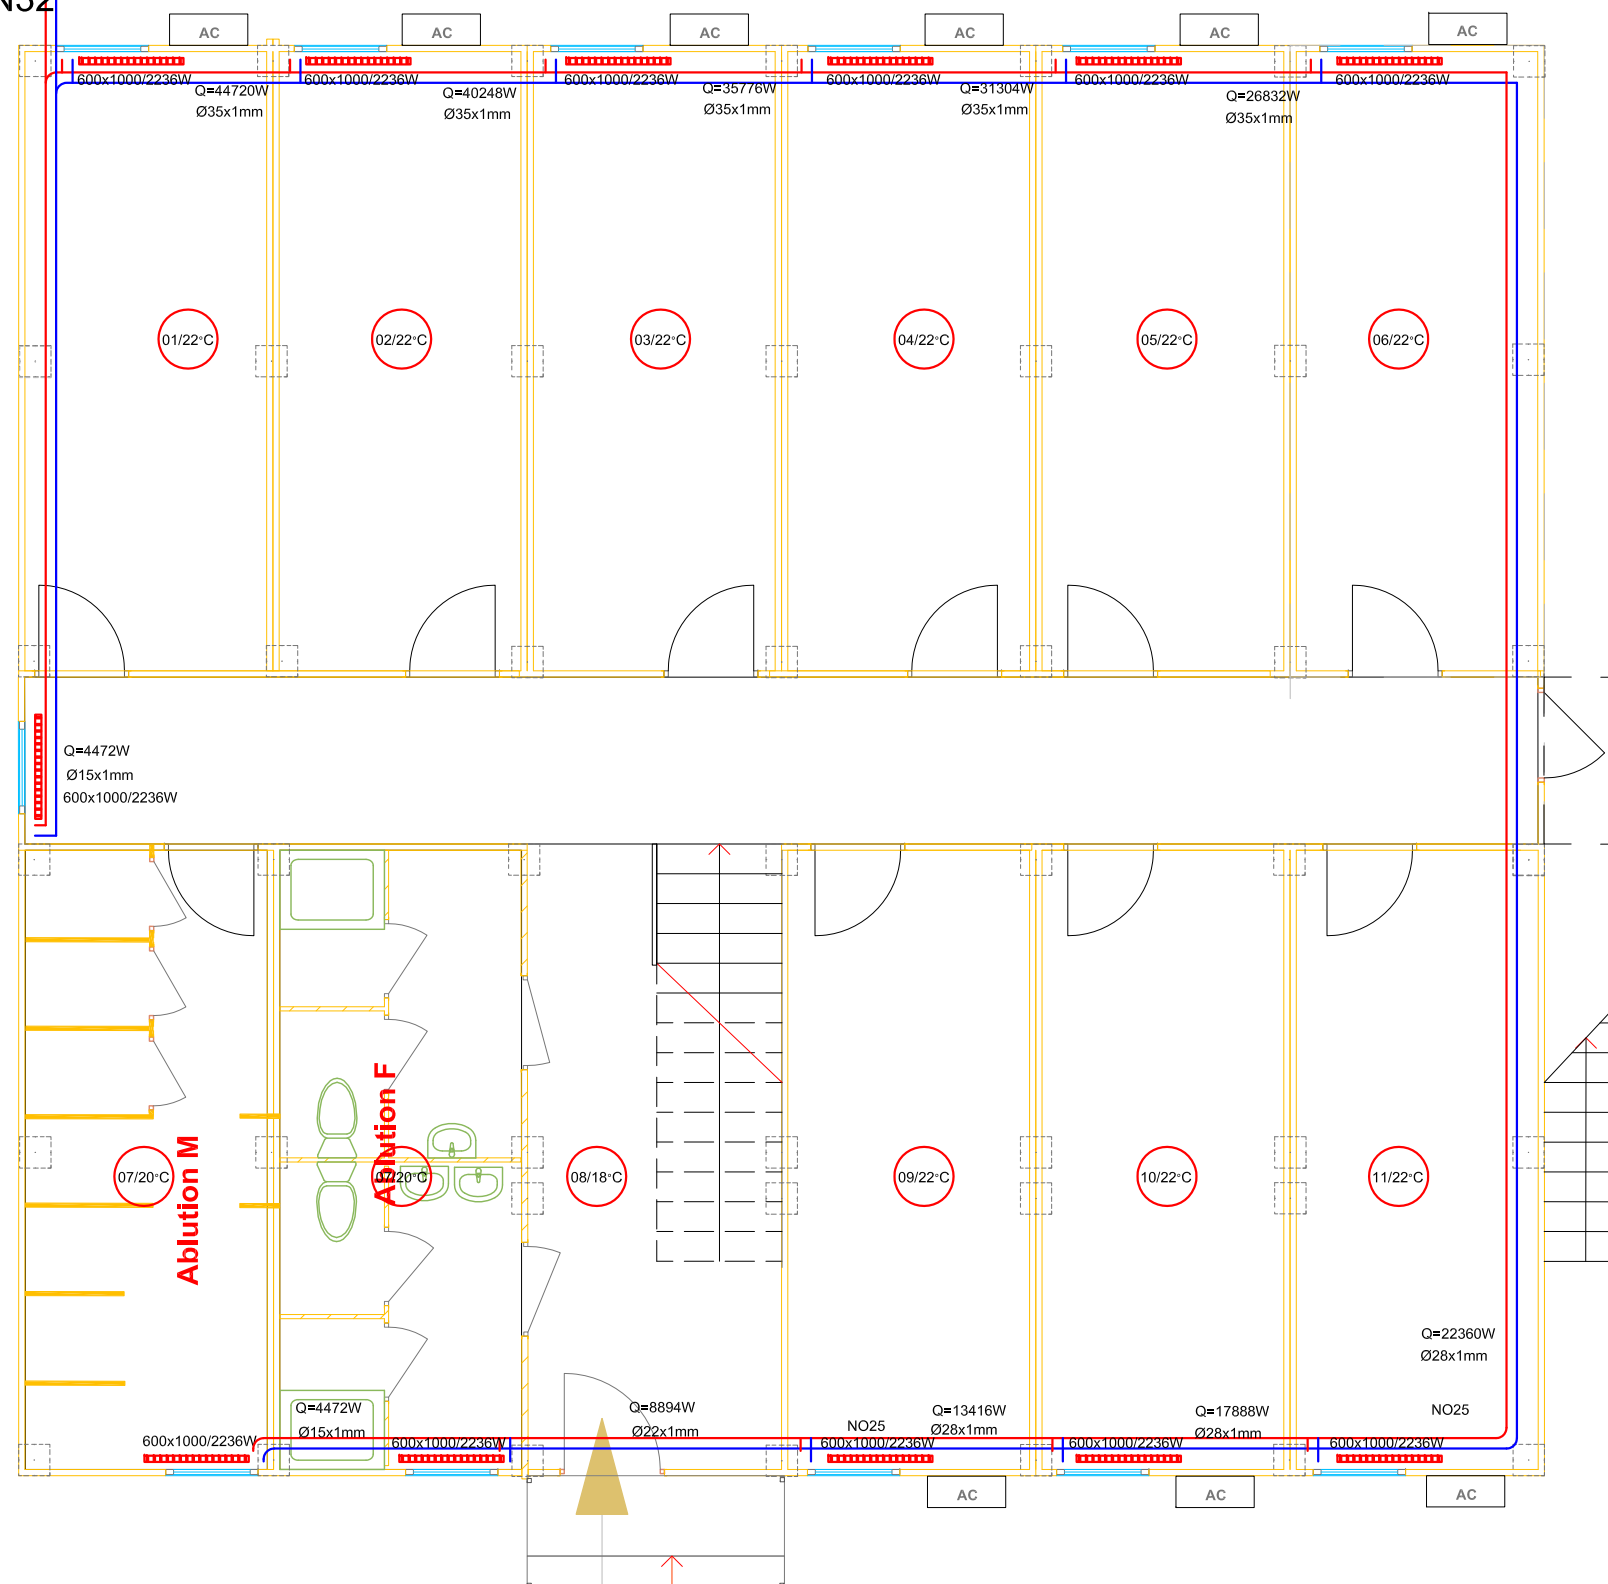


Ground Floor, Rn block

entrance


PROJECT:	Eulex MITROVICA Camp		
DRAWING:	Ground floor Rn - Heating system		
CHECKED BY:			
DESIGNED BY:			
SCALE:	1:100		
UNIT	cm		
DRAWING No:	11	B2	
DATE:	MAY 2010		



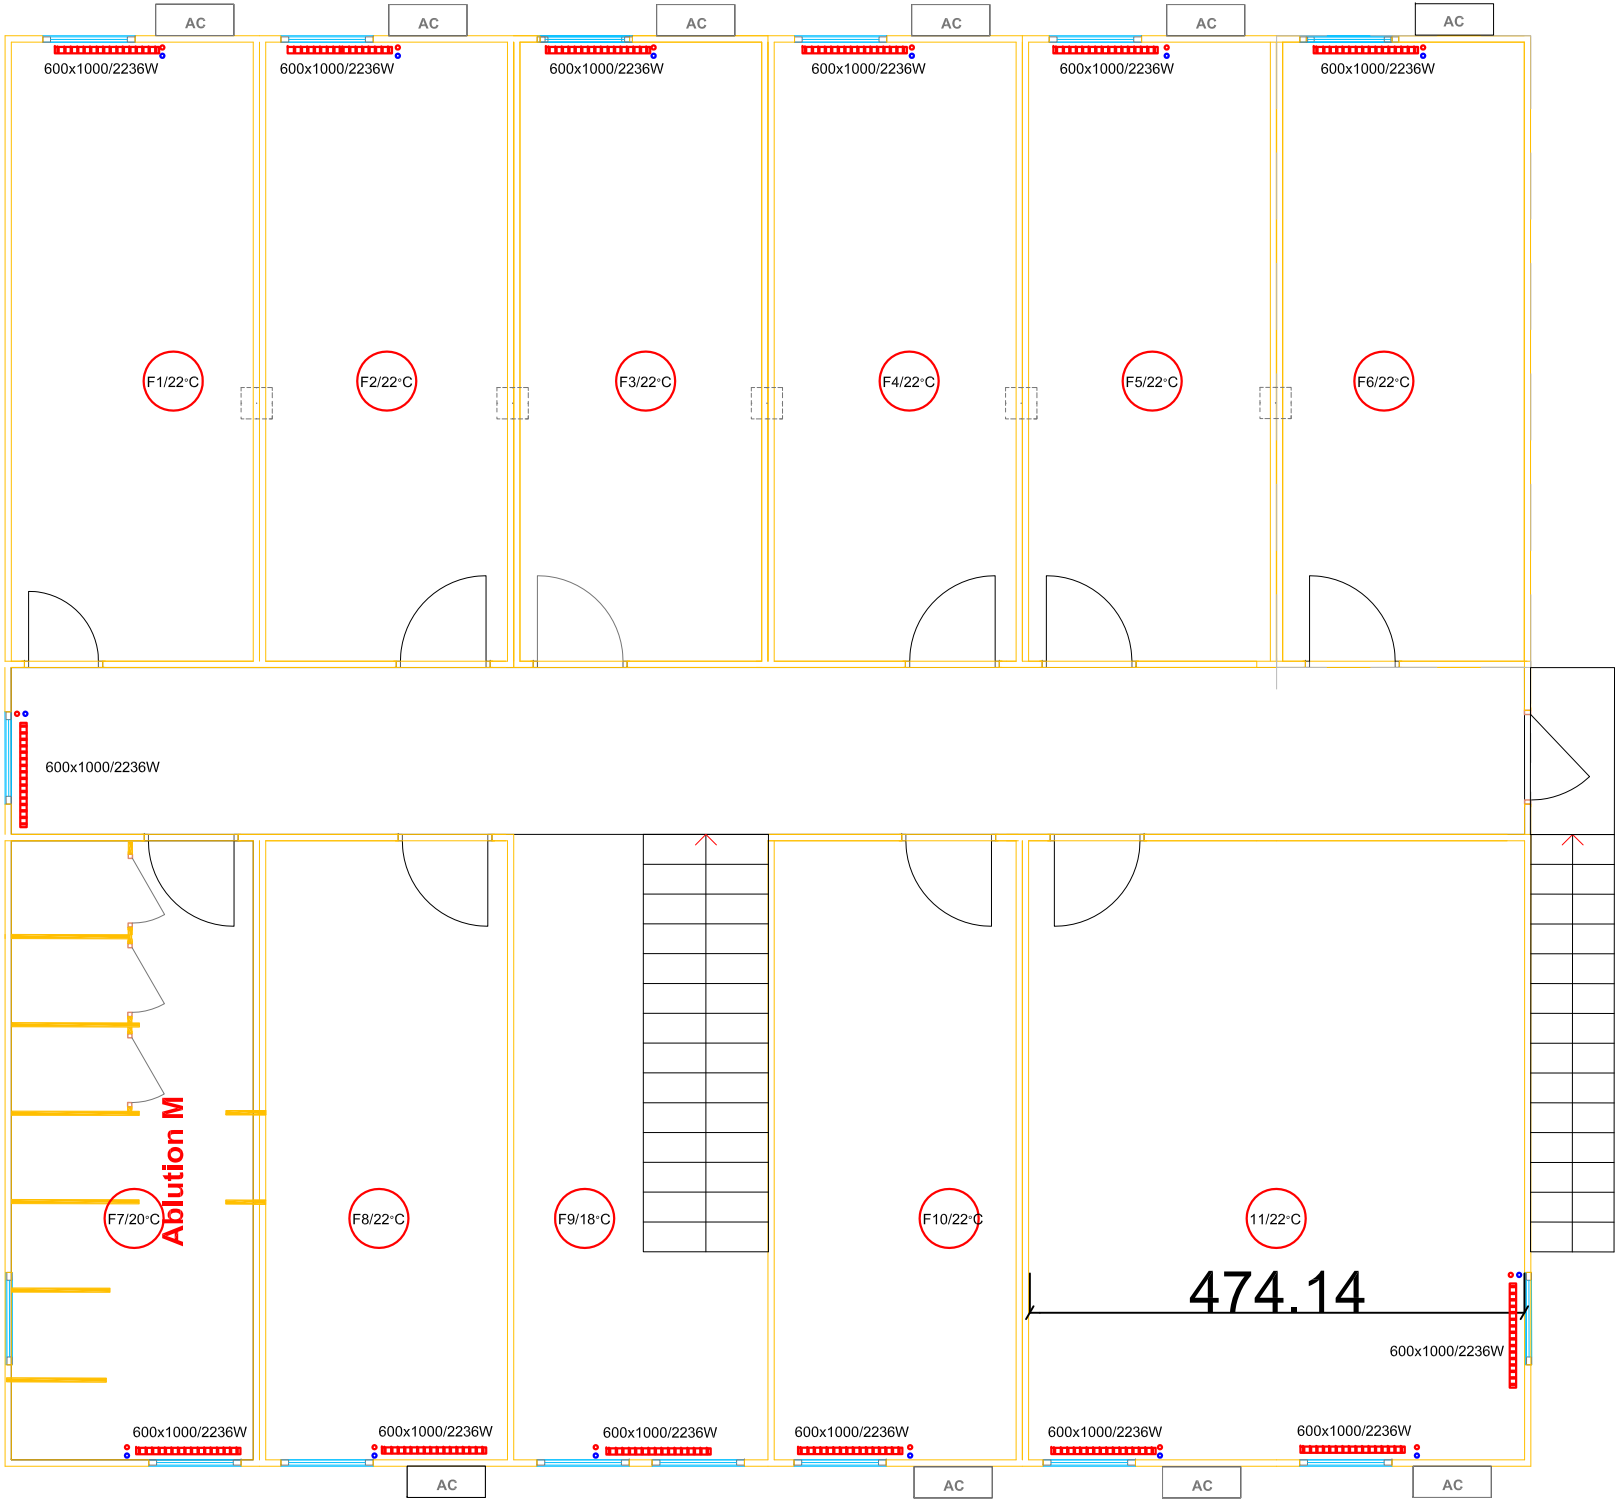


First floor, Rn block

PROJECT:	Eulex MITROVICA Camp		
DRAWING:	First floor Rn - Heating system		
CHECKED BY:			
DESIGNED BY:			
SCALE:	1:100		
UNIT	cm		
DRAWING No:	12	B2	
DATE:	MAY 2010		



BUILDING MANAGEMENT SECTION

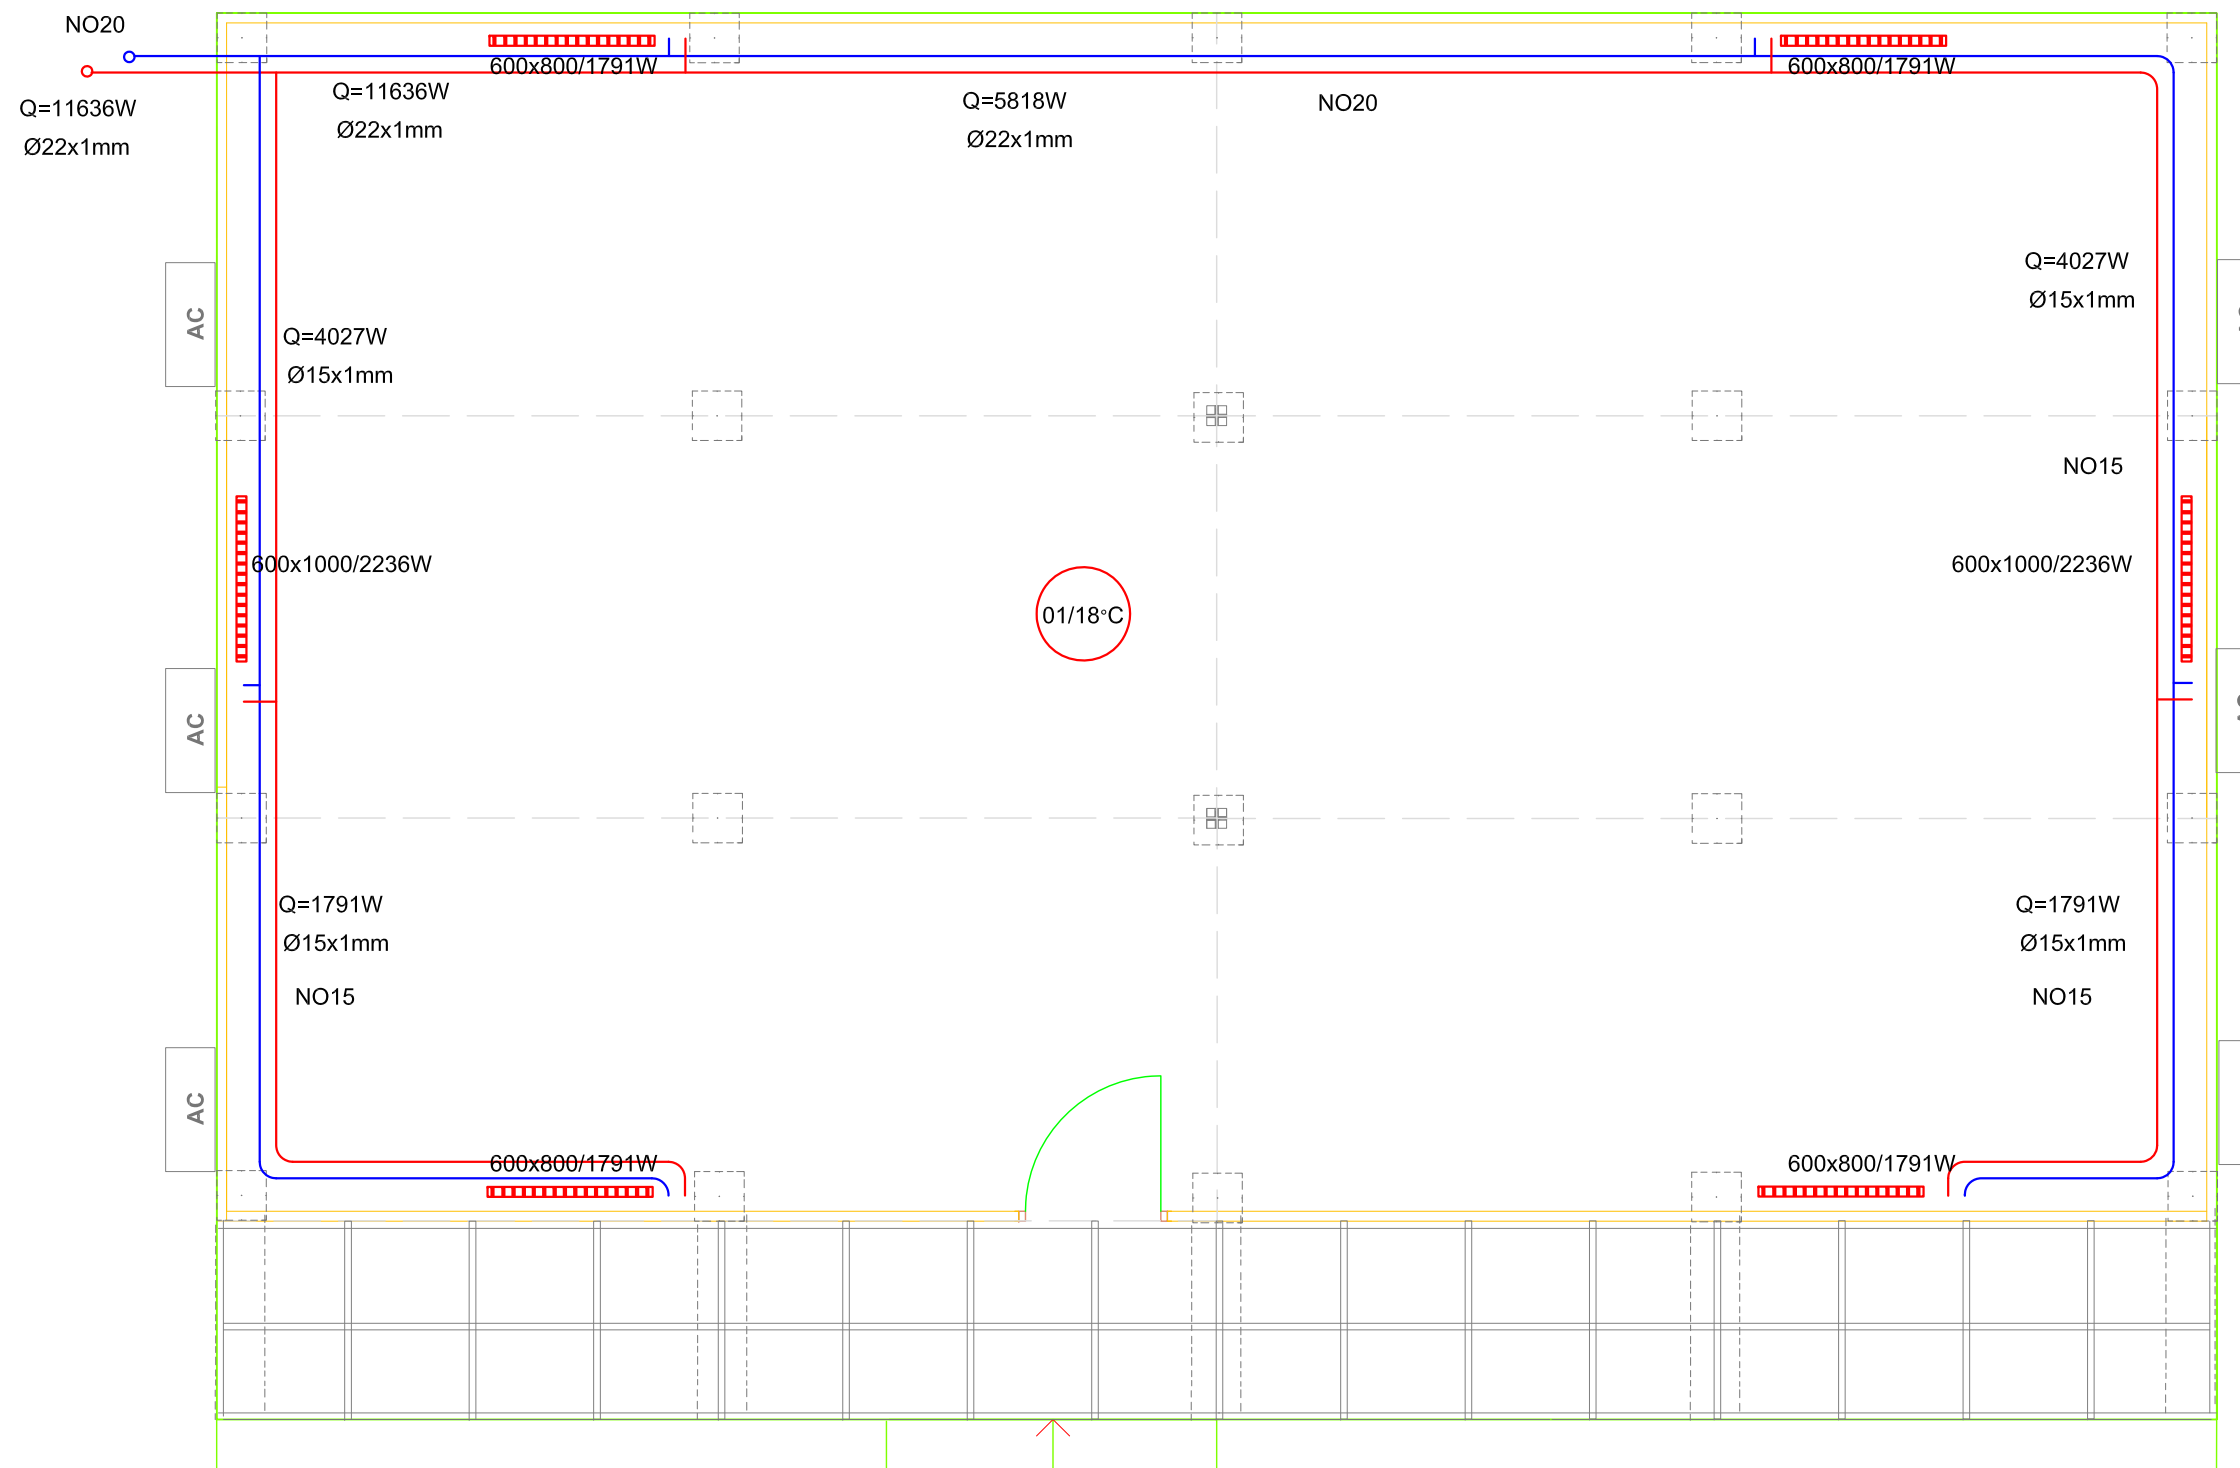


Floor Plan of Church

PROJECT:	Eulex MITROVICA Camp		
DRAWING:	Church - Heating system		
CHECKED BY:			
DESIGNED BY:			
SCALE:	1:100		
UNIT	cm		
DRAWING No:	13	B2	
DATE:	MAY 2010		




BUILDING MANAGEMENT SECTION

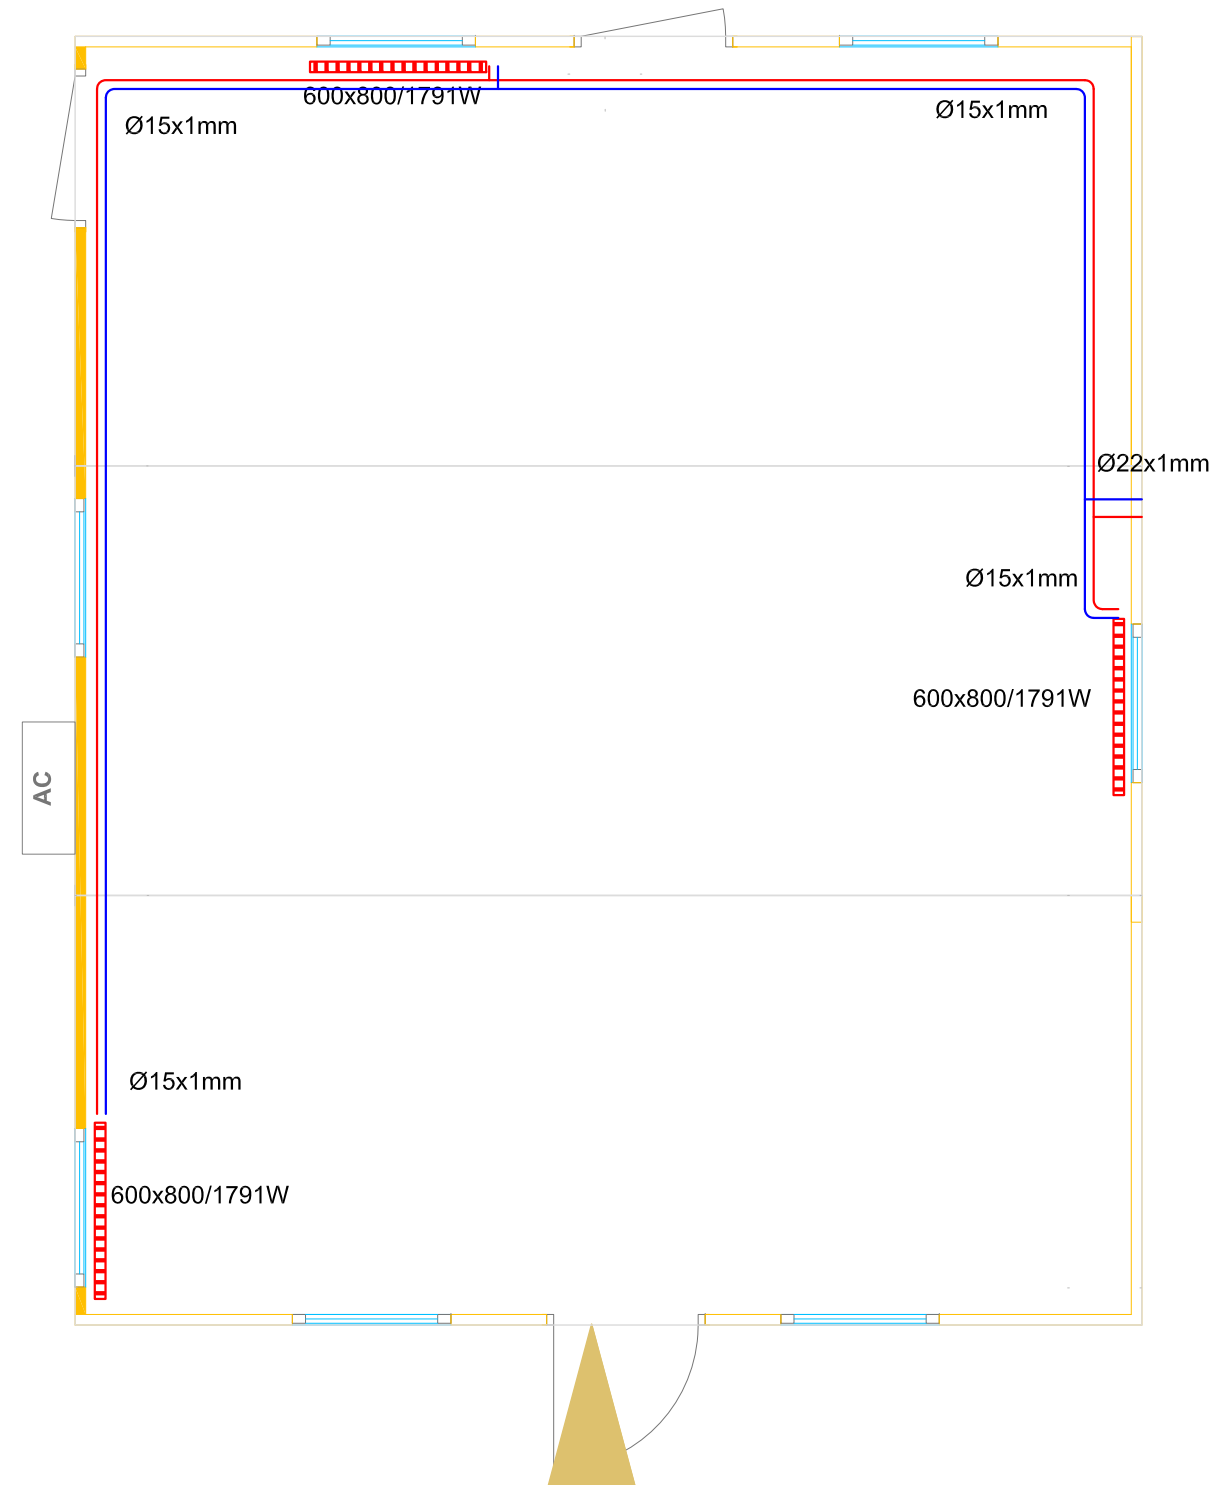

Floor Plan of "K" block, Px
entrance

PROJECT:	Eulex MITROVICA Camp		
DRAWING:	"K" block, Px - Heating system		
CHECKED BY:			
DESIGNED BY:			
SCALE:	1:100		
UNIT	cm		
DRAWING No:	15	B2	
DATE:	MAY 2010		




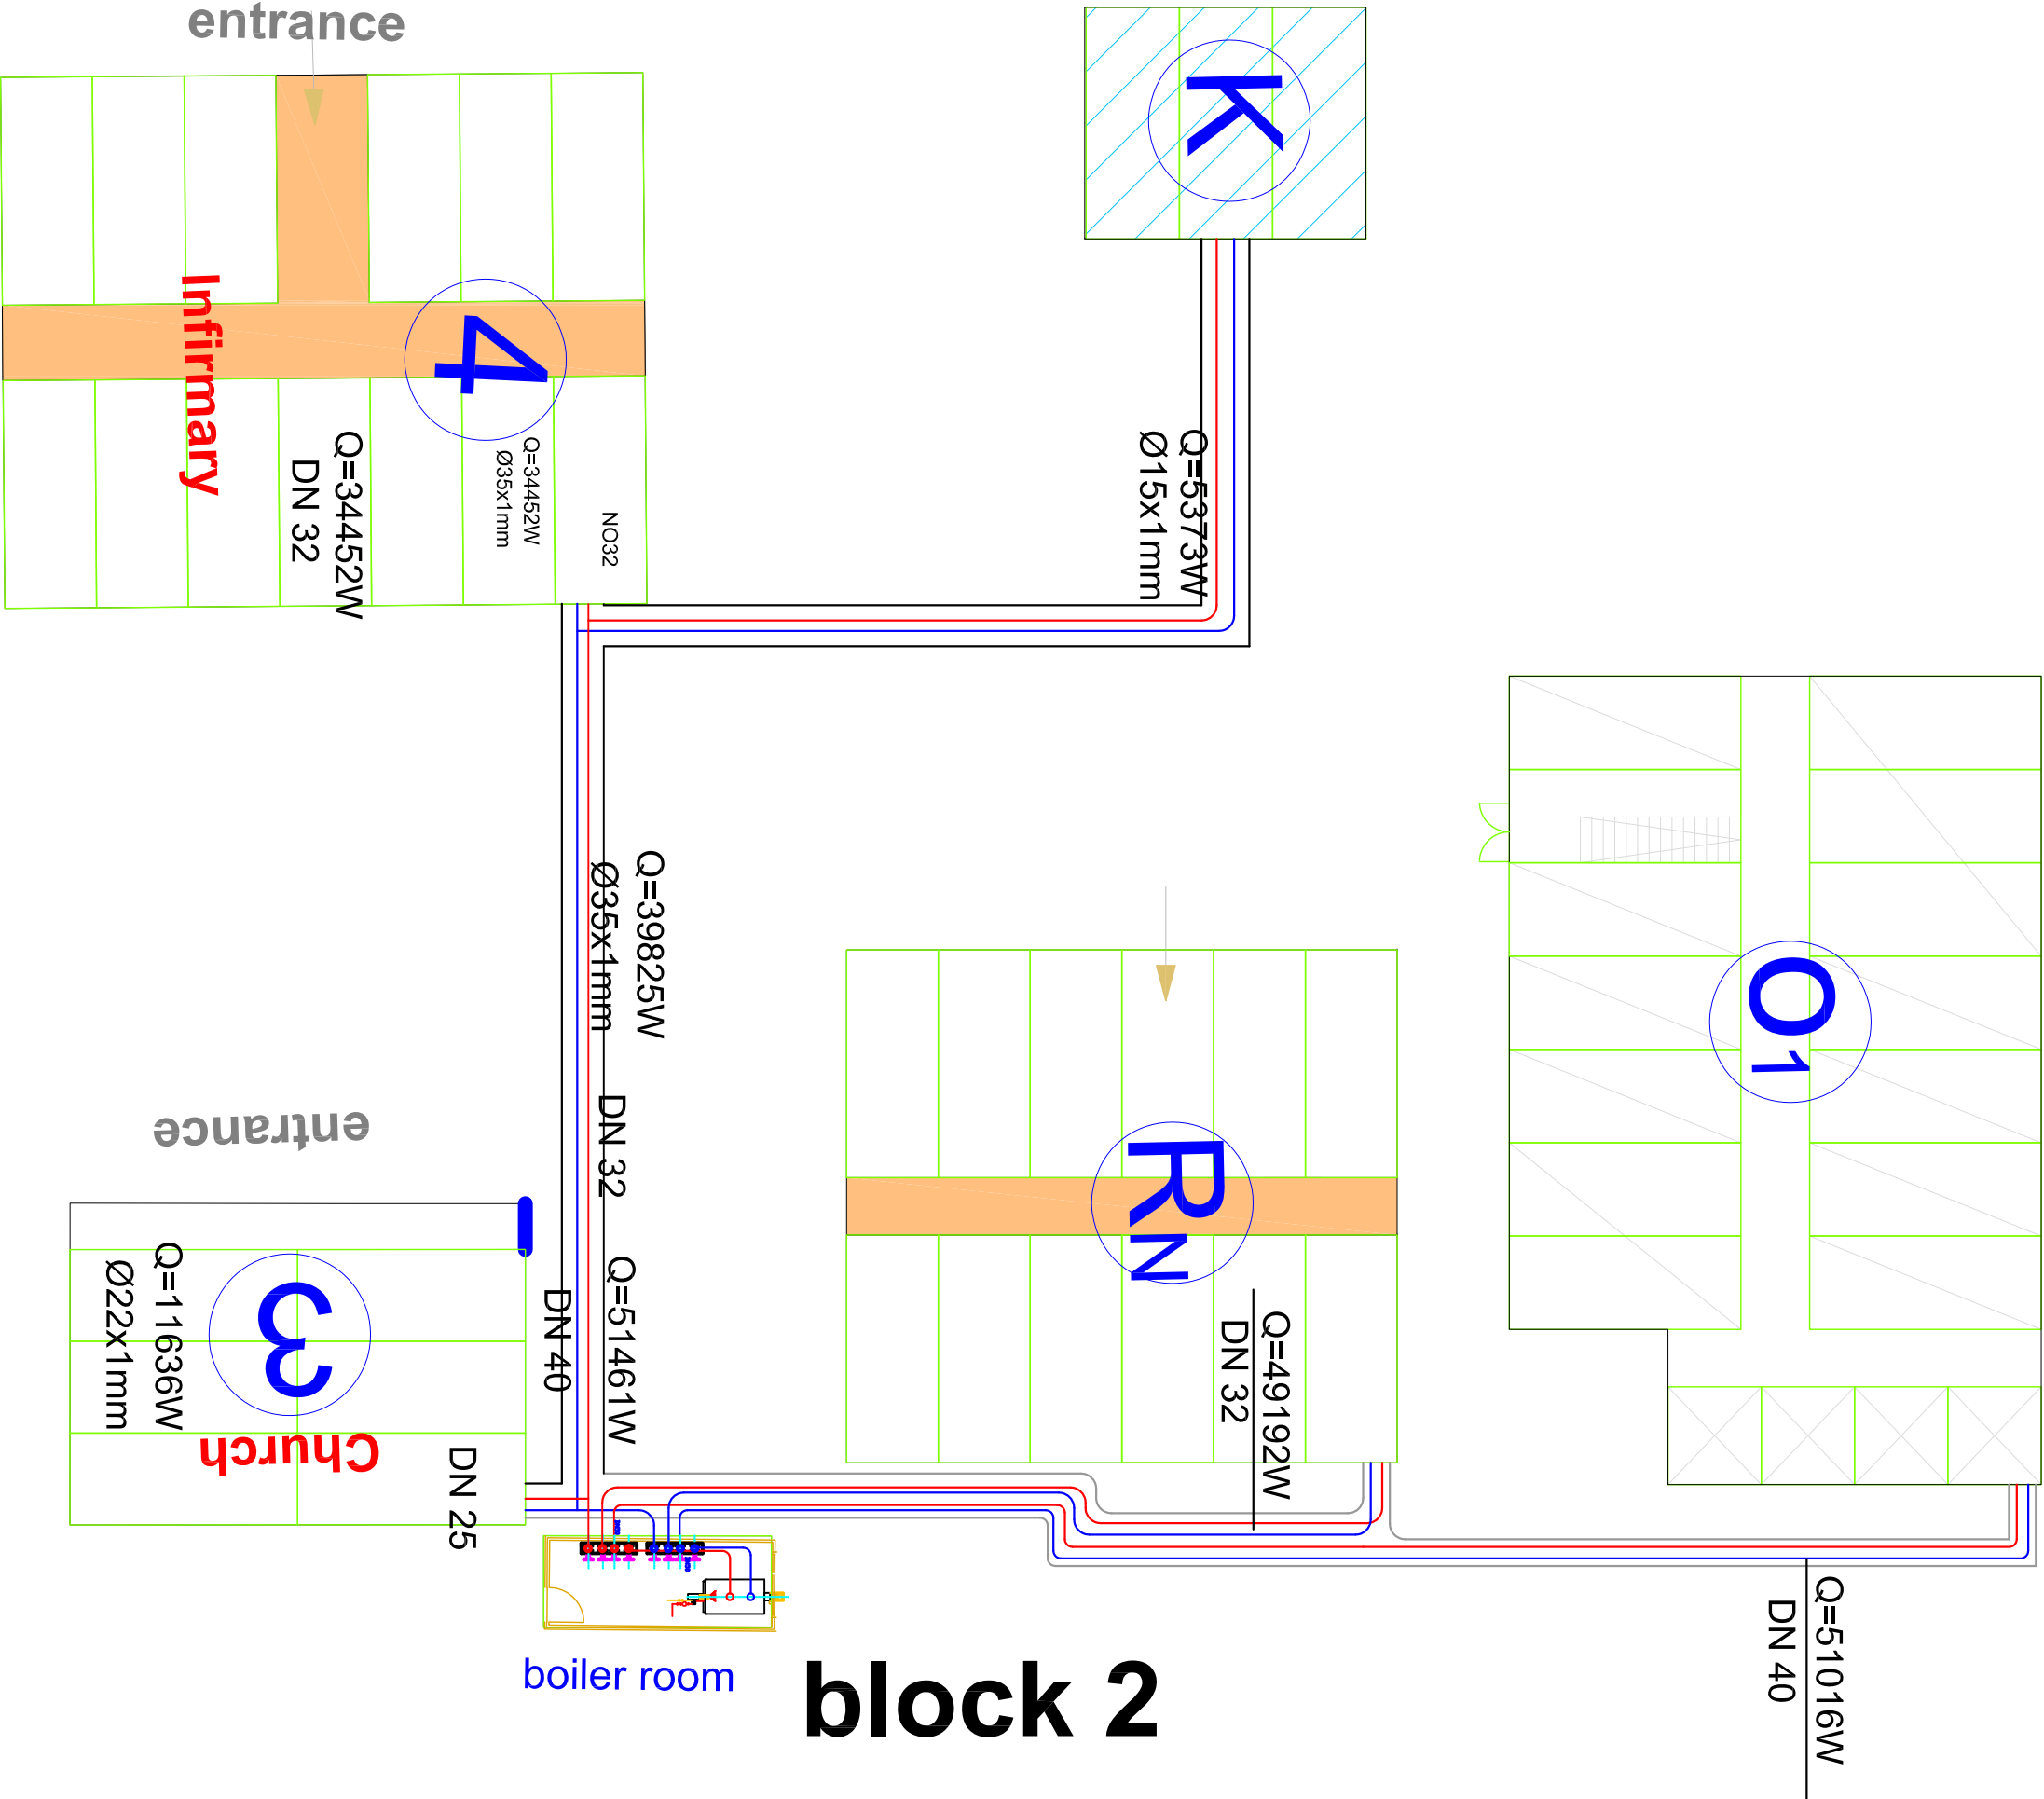

PROJECT:	Eulex MITROVICA Camp			
DRAWING:	Pipe network for heating - BLOCK 2			
CHECKED BY:				
DESIGNED BY:				
SCALE:	1:100			
UNIT	cm			
DRAWING No:	16	B2		
DATE:	MAY 2010			



BUILDING MANAGEMENT
SECTION

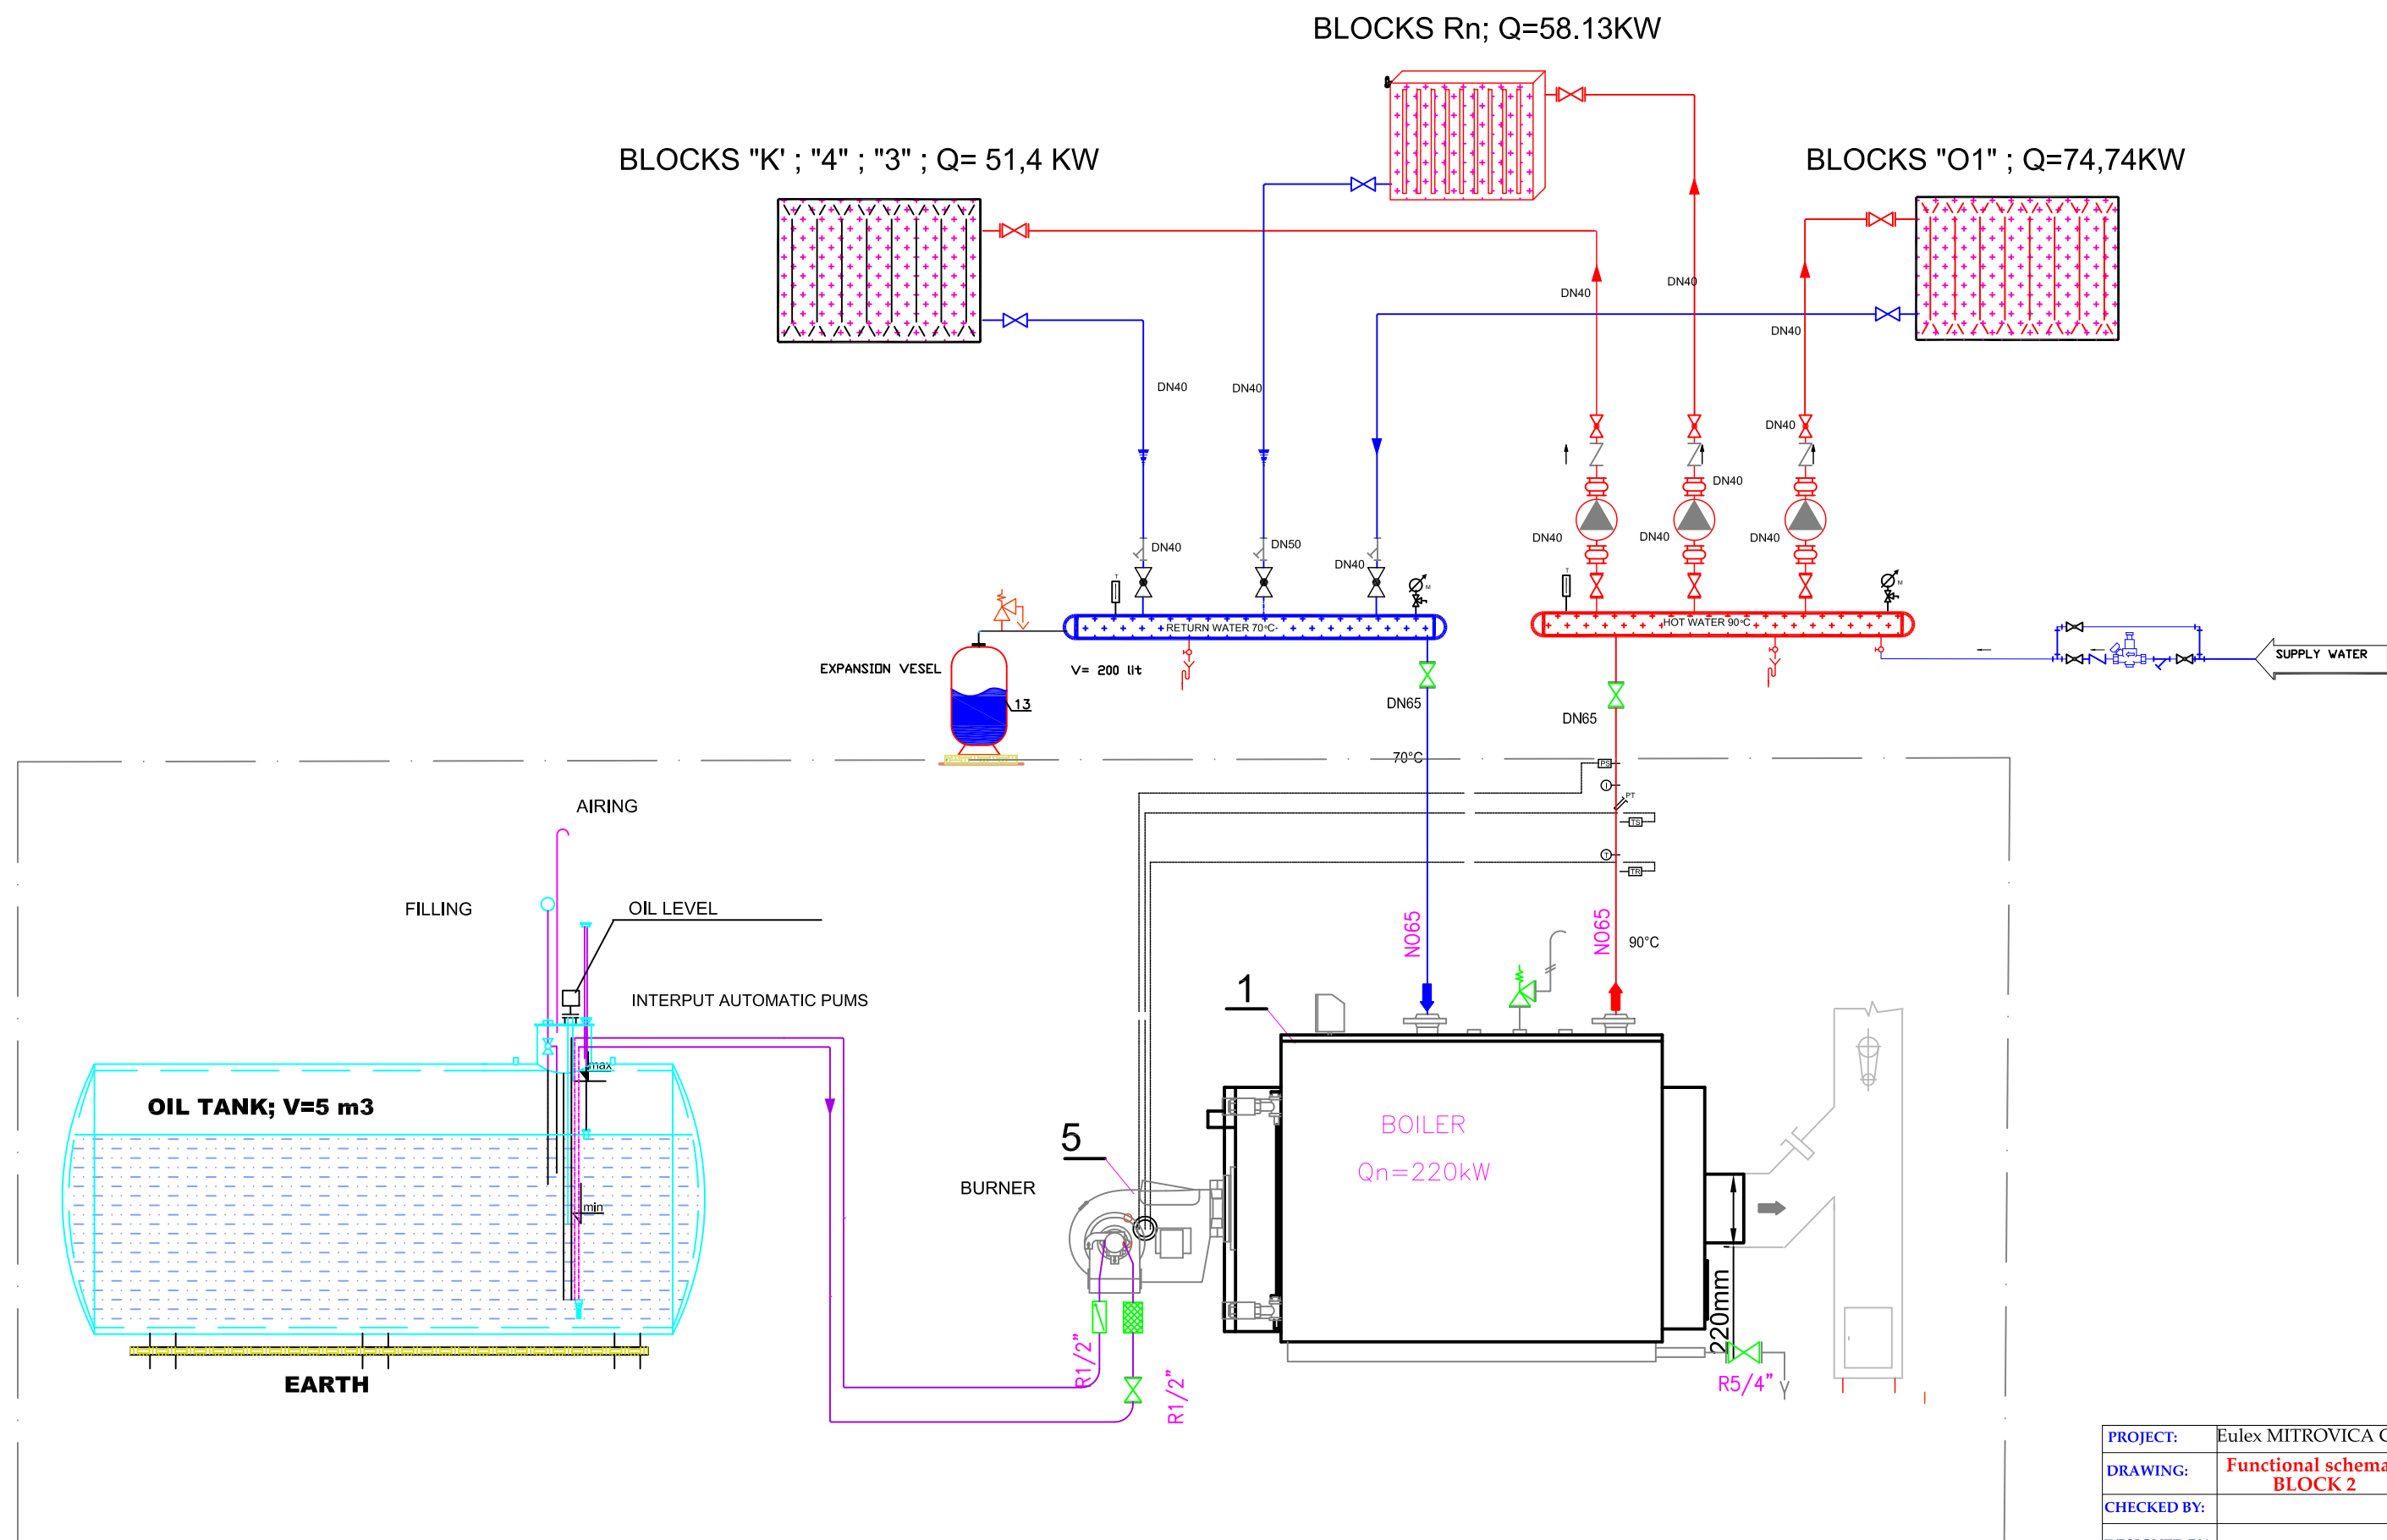

PROJECT:	Eulex MITROVICA Camp		
DRAWING:	Functional schema - BLOCK 2		
CHECKED BY:			
DESIGNED BY:			
SCALE:	1:100		
UNIT:	cm		
DRAWING No:	17	B2	
DATE:	MAY 2010		



BUILDING MANAGEMENT