
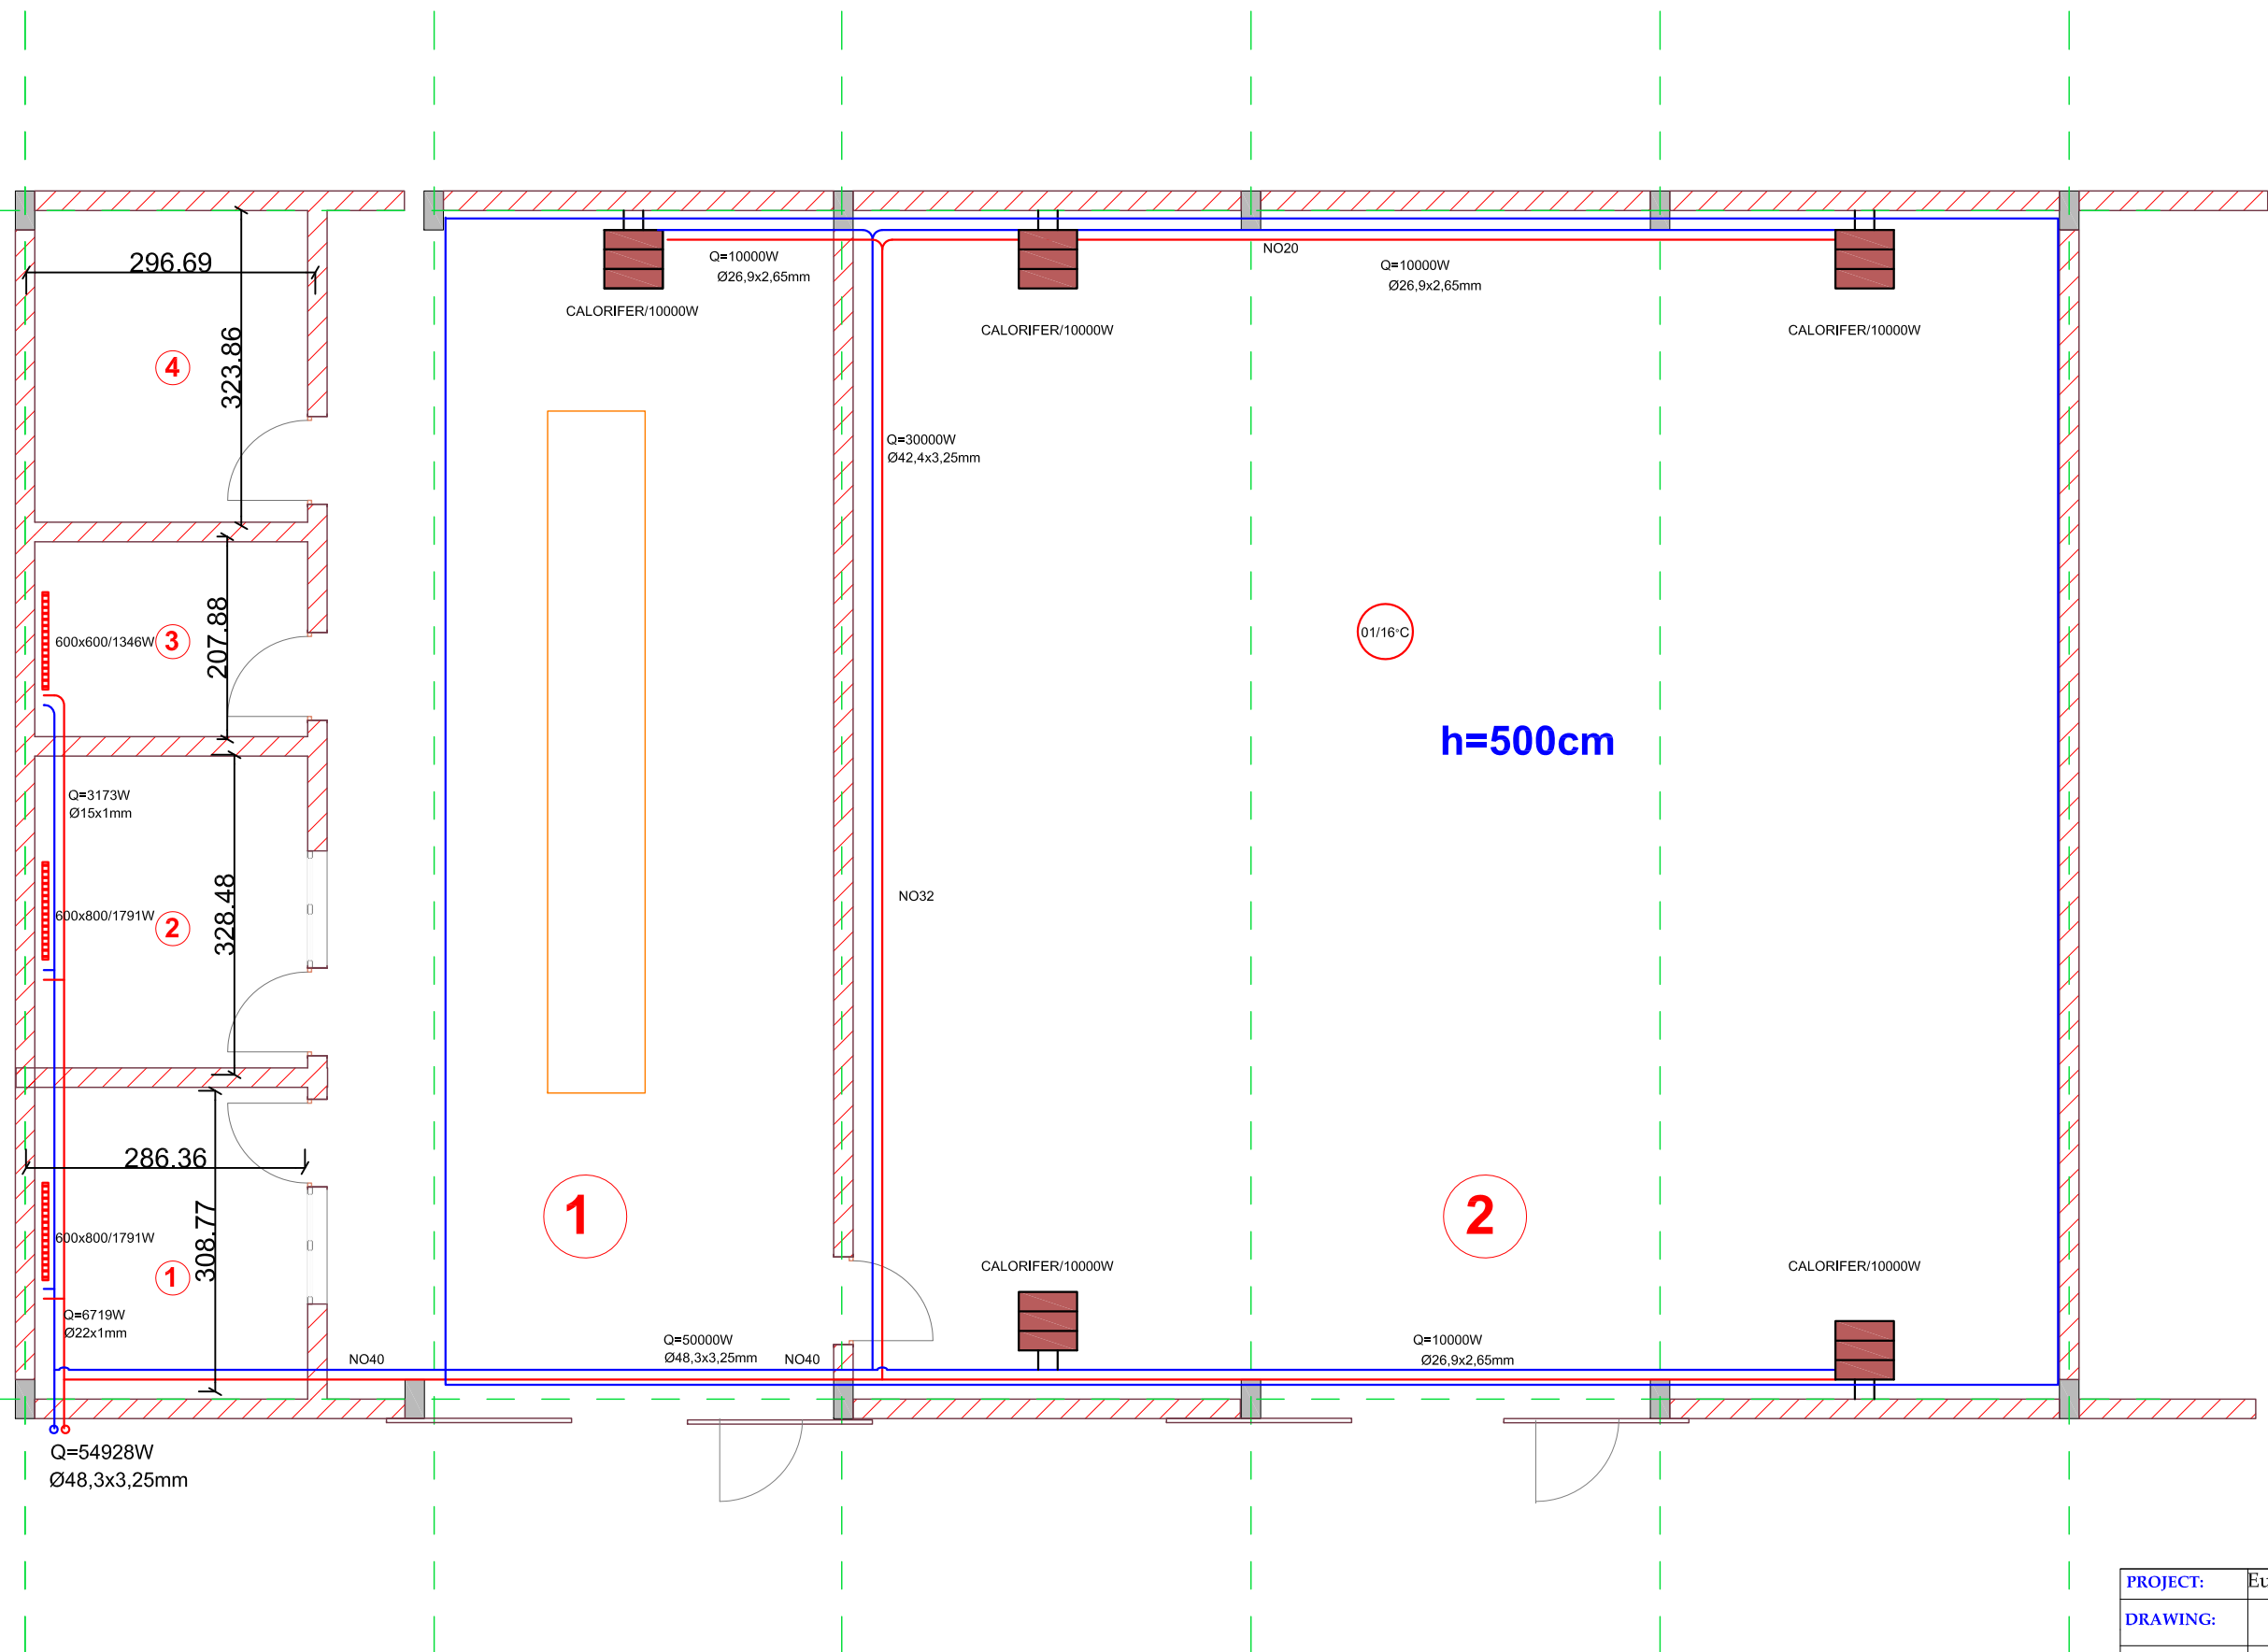




Floor Plan of Restaurant & Kitchen

PROJECT:	Eulex MITROVICA Camp		
DRAWING:	Restaurant & kitchen - Heating system		
CHECKED BY:			
DESIGNED BY:			
SCALE:	1:100		
UNIT	cm		
DRAWING No:	18	B3	
DATE:	MAY 2010		



BUILDING MANAGEMENT SECTION



Floor Plan "W" Workshop


PROJECT:	Eulex MITROVICA Camp		
DRAWING:	"W" Workshop - Heating system		
CHECKED BY:			
DESIGNED BY:			
SCALE:	1:100		
UNIT	cm		
DRAWING No:	19	B3	
DATE:	MAY 2010		



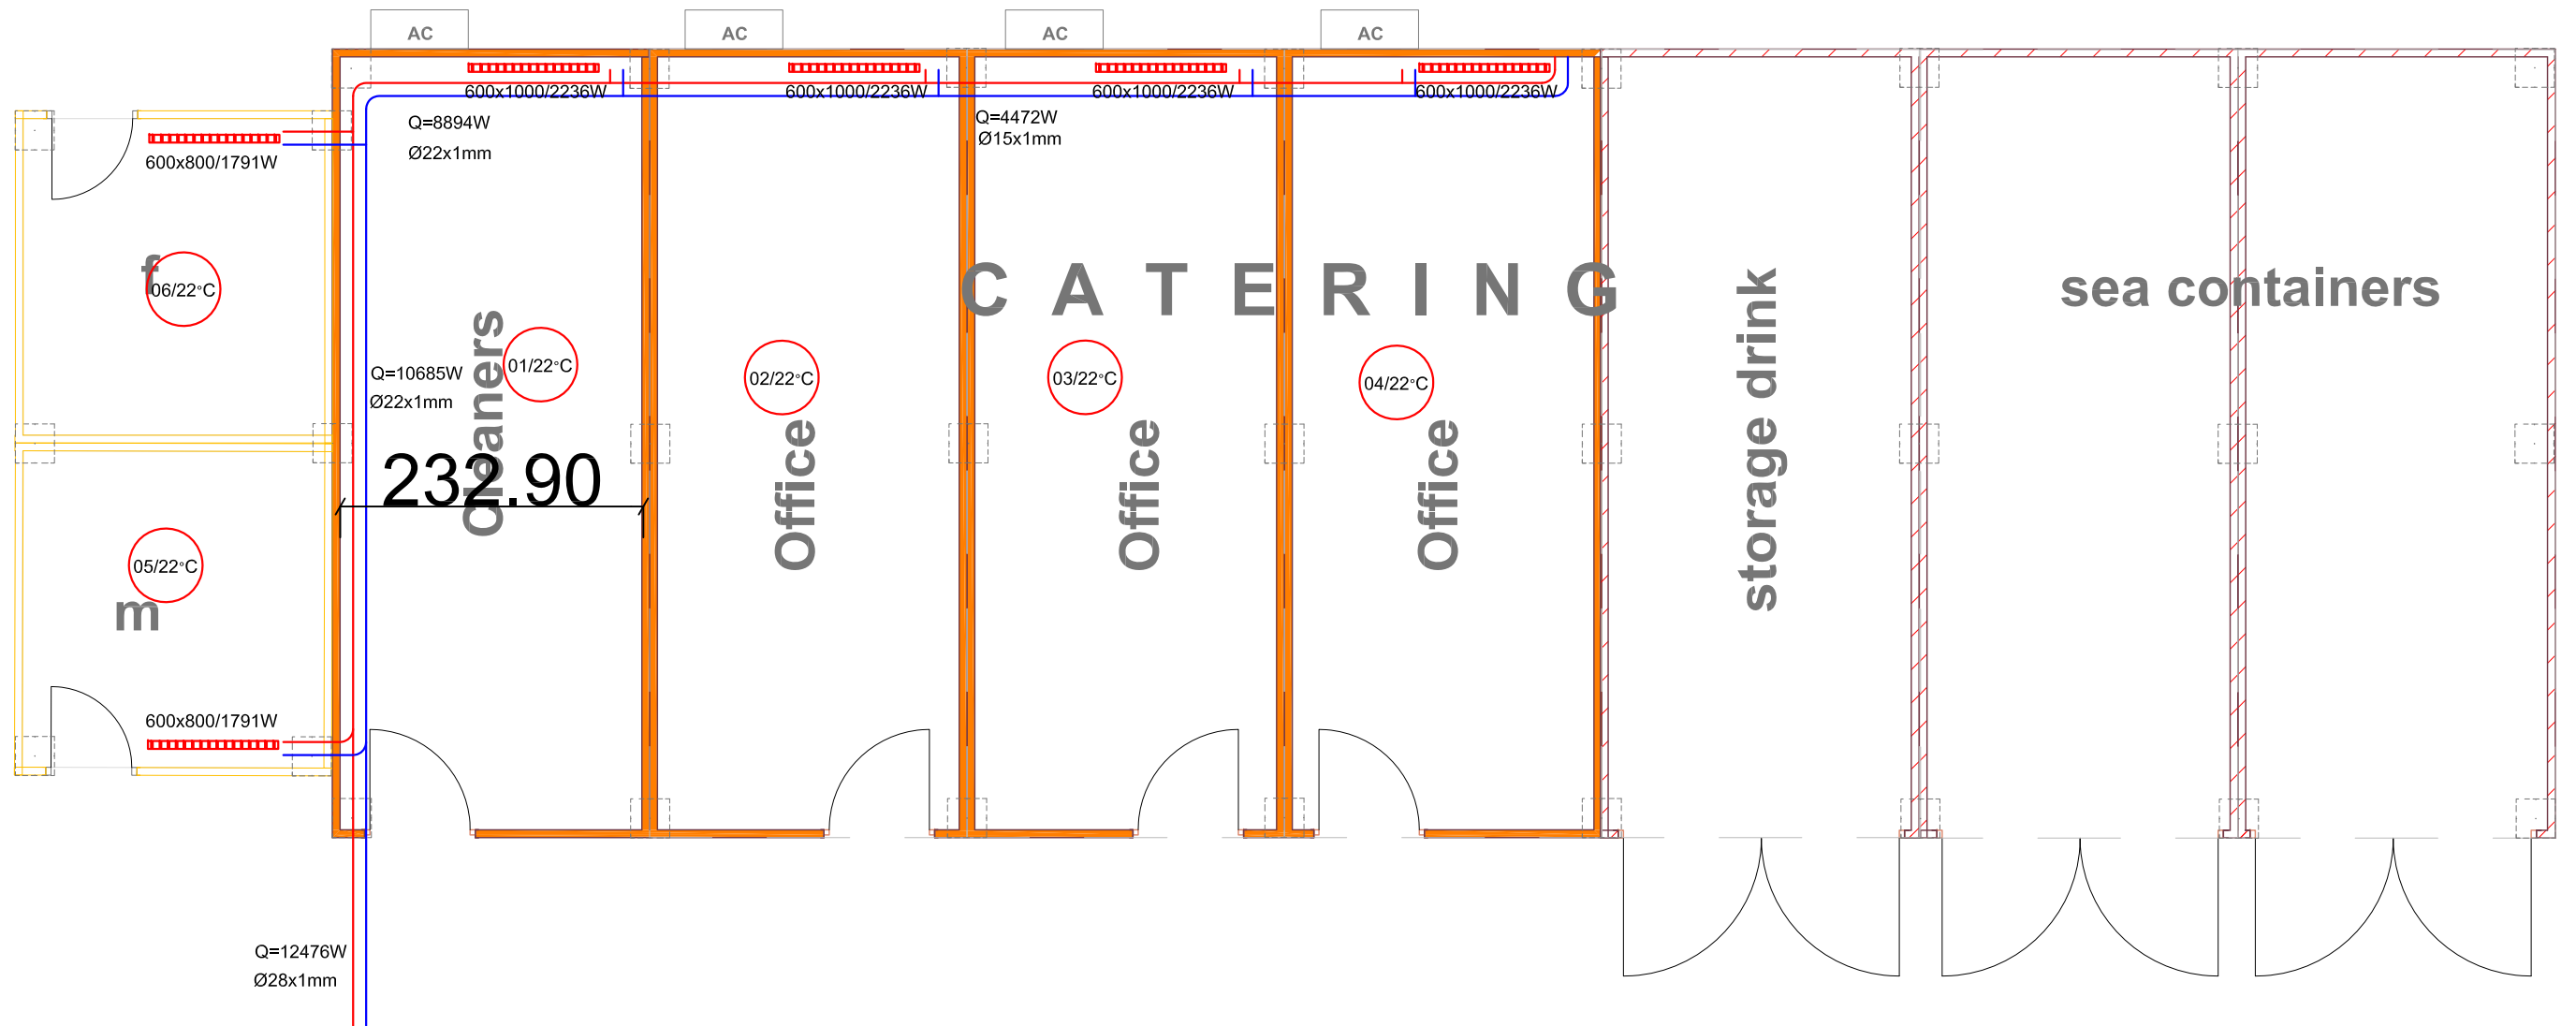

PROJECT:	Eulex MITROVICA Camp		
DRAWING:	Catering - Heating system		
CHECKED BY:			
DESIGNED BY:			
SCALE:	1:100		
UNIT	cm		
DRAWING No:	20	B3	
DATE:	MAY 2010		



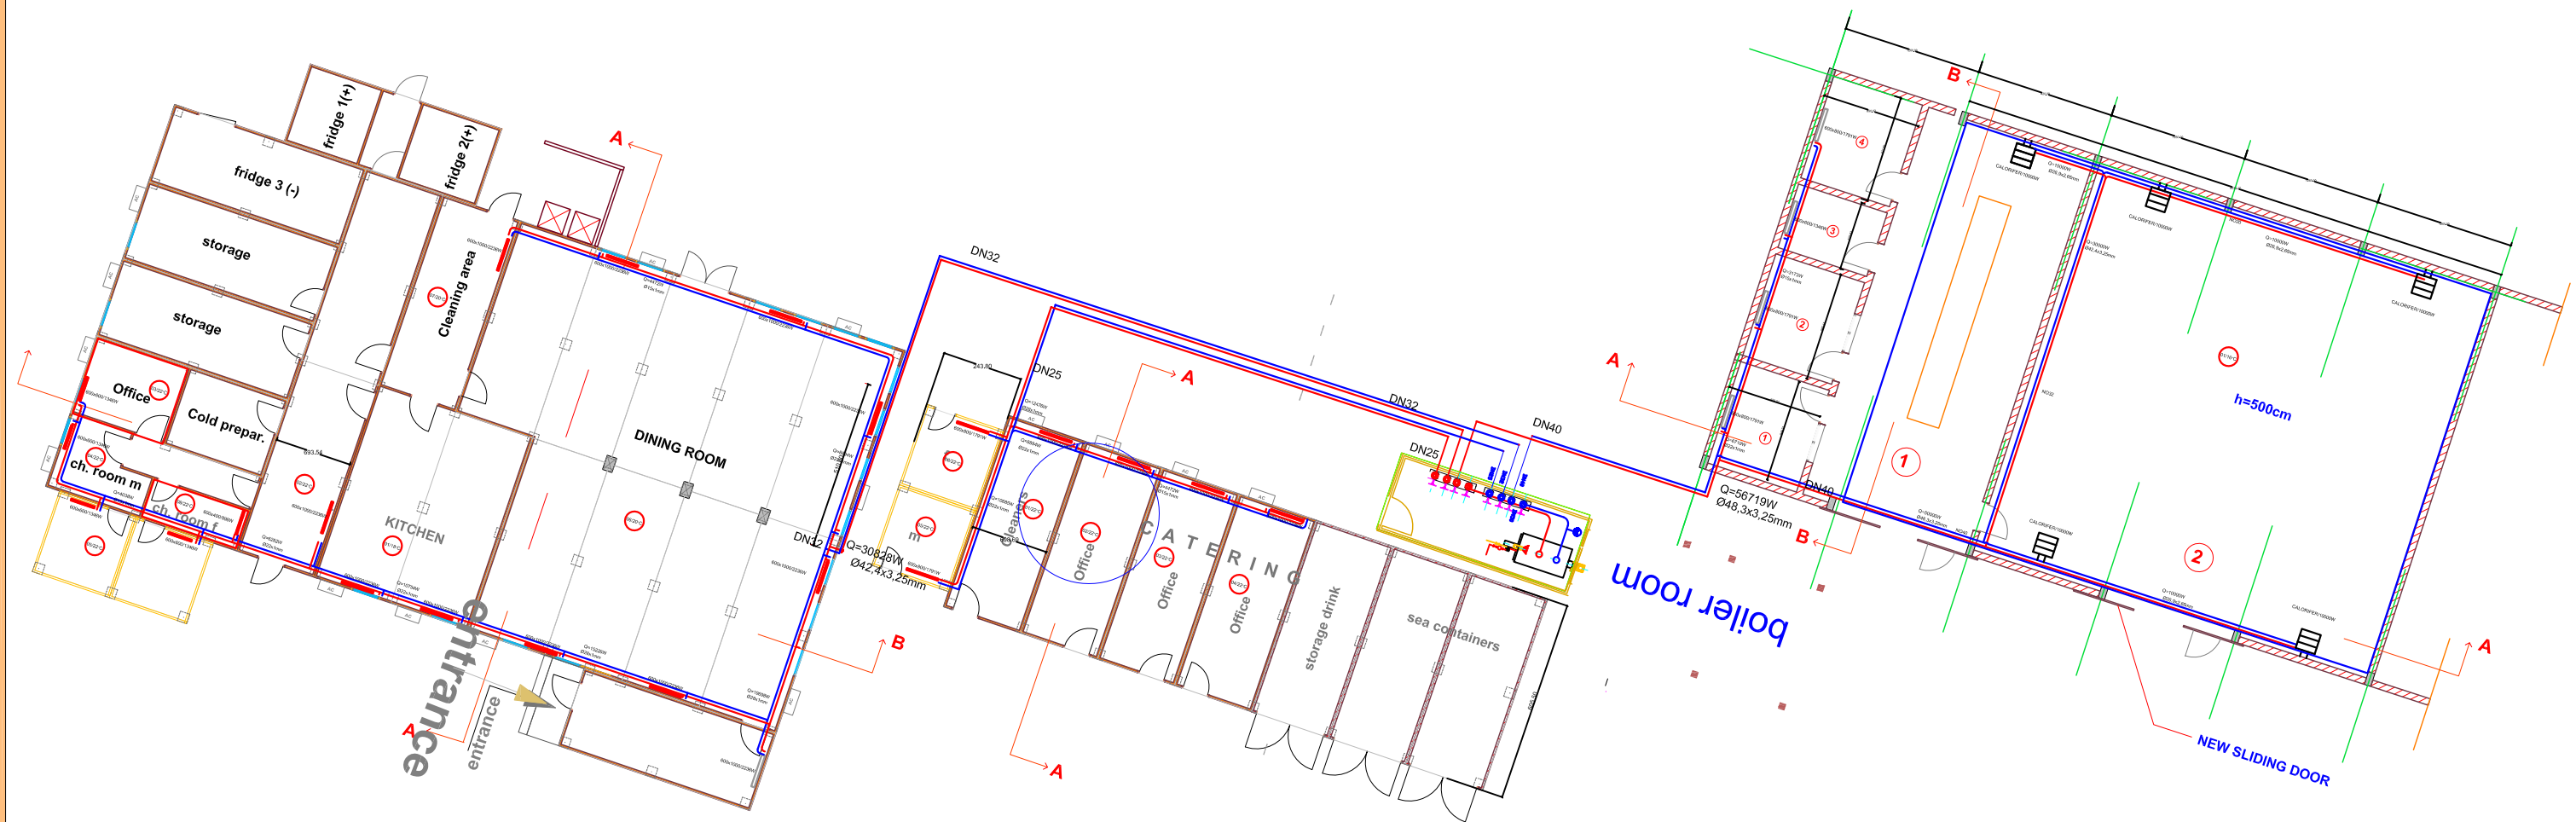


PROJECT:	Eulex MITROVICA Camp		
DRAWING:	Pipe network - BLOCK 3		
CHECKED BY:			
DESIGNED BY:			
SCALE:	1:100		
UNIT:	cm		
DRAWING No:	21	B3	
DATE:	MAY 2010		



BLOCKS "2 KATERING " ; Q= 12,4 KW

BLOCKS " W WORKSHOP" ; Q=54,9 kW

BLOCKS "1 RESTORAN"; Q=30,8KW

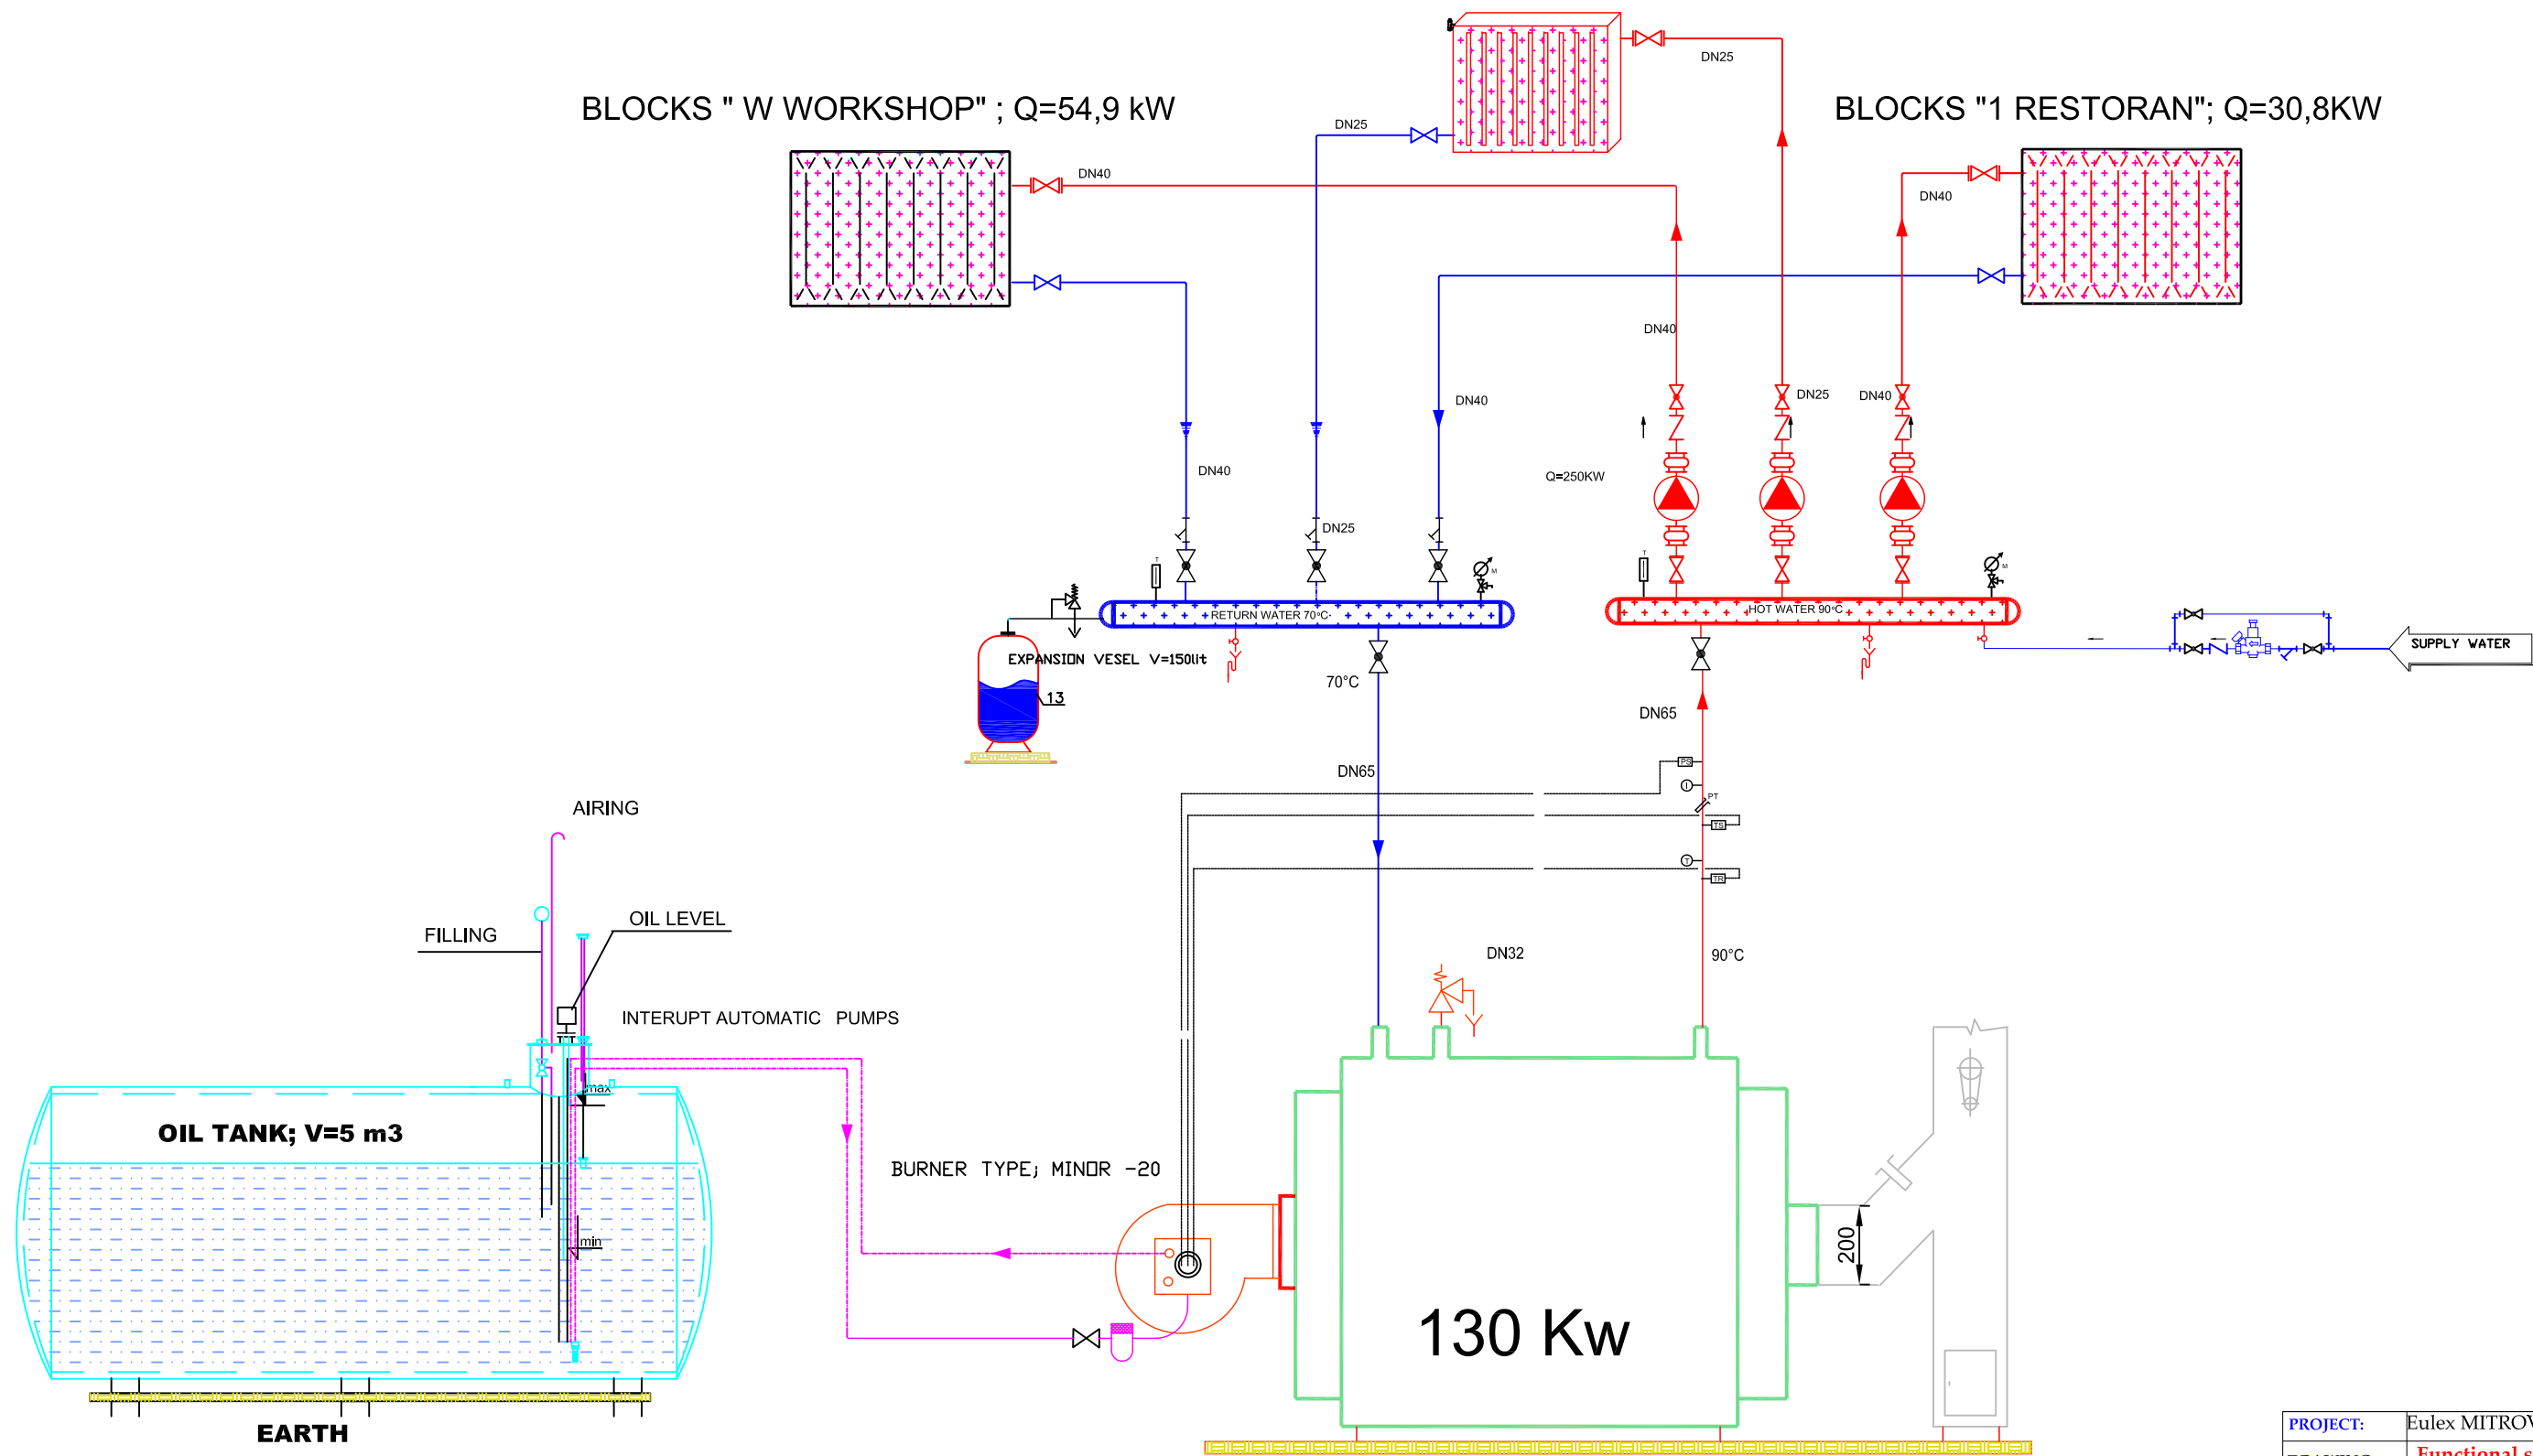

PROJECT:	Eulex MITROVICA Camp		
DRAWING:	Functional schema - BLOCK 3		
CHECKED BY:			
DESIGNED BY:			
SCALE:	1:100		
UNIT	cm		
DRAWING No:	22	B3	
DATE:	MAY 2010		

